


SYMBOL LIST				
No	SYMBOL	DESCRIPTION	TYPE	QTY
1		16A SWITCHED TWIN SOCKET-OUTLET WITH SAFETY SHUTTERS 250V. 2P + EARTH WITH SIDE CONTACTS. FLUSH MOUNTED 300mm AFFL.	CLIPSAL S2000 OR EQUAL	6
2		16A SWITCHED TWIN SOCKET-OUTLET WITH SAFETY SHUTTERS 250V. 2P + EARTH WITH SIDE CONTACTS. FLUSH MOUNTED 1200mm AFFL.	CLIPSAL S2000 OR EQUAL	2
3		RSA STANDARD 16A TWIN SOCKET-OUTLET WITH SAFETY SHUTTERS 250V. 2P+EARTH WITH SIDE CONTACTS. FLUSH MOUNTED ON POWER SKIRTING.	CLIPSAL S2000 OR EQUAL	-
4		OUTLET CLUSTER TYPE A MOUNTED ON POWER SKIRTING WITH 2x RSA STANDARD 16A SOCKET-OUTLET + 1x RJ45 DATA/COMPUTER NETWORK POINT, SHIELDED. SUITABLE FOR CATEGORY 6, FOR 10/250MB FAST ETHERNET NETWORKS + 1x RJ45 TELEPHONE SOCKET + 1x RSA STANDARD 16A SWITCHED DEDICATED SOCKET OUTLET. POWER SKIRTING WITH SAFETY SHUTTERS 250V.	CABSTRUT CLASSIC GC/2 OR EQUAL	54
5		ROUND BOX FOR AC CONTROLLER		-
6		INTERCOM. MAKE PROVISION FOR INTERCONNECTING INTERCOM CABLE WIRE WAY AND 60mm ROUND BOX AT 2300AFFL. ALL BUILDINGS TO CONNECT BACK TO ADMIN HEADMASTER OFFICE VIA 32mm SLEEVE		-
7		MULTI COMPARTMENT FLEXIBLE POWER SKIRTING MOUNTED AT FFL. COMPLETE WITH SNAP-ON COVERS, ELBOWS, END CAPS etc. DIMS. OF AT LEAST 150mm x 50mm.	CABSTRUT CLASSIC GC/2 OR EQUAL	95m
8		ROTARY WALL-MOUNTING ISOLATOR SWITCH WITH RED PADLOCKABLE KNOB ON YELLOW FLANGE. DP 16A, 32A OR 63A. IP-65. RATING AS SHOWN	GEWISS GW 70431/4/7 OR SIMILAR APPROVED	-
9		ROTARY WALL-MOUNTING ISOLATOR SWITCH WITH RED PADLOCKABLE KNOB ON YELLOW FLANGE. TP 16A, 20A, 32A OR 63A. IP-65.	GEWISS GW 70431/4/7 OR SIMILAR APPROVED	4
10		EPOXY COATED, SHEETMETAL POWER DISTRIBUTION ENCLOSURE. FLUSH MOUNTED 1400mm AFFL.	GEM OR SIMILAR APPROVED	2
11		RECESSED FLOOR OF DESK SOCKET OUTLET CLUSTER WITH 2x RSA STANDARD 16A SOCKET-OUTLET + 1x RJ45 DATA/COMPUTER NETWORK POINT, SHIELDED. SUITABLE FOR CATEGORY 6A, FOR 10/100MB FAST ETHERNET NETWORKS + 1x RJ45 TELEPHONE SOCKET + 1x RSA STANDARD 16A SWITCHED DEDICATED SOCKET OUTLET. WITH SAFETY SHUTTERS 250V.	CABSTRUT CLASSIC GC/2 OR EQUAL	1

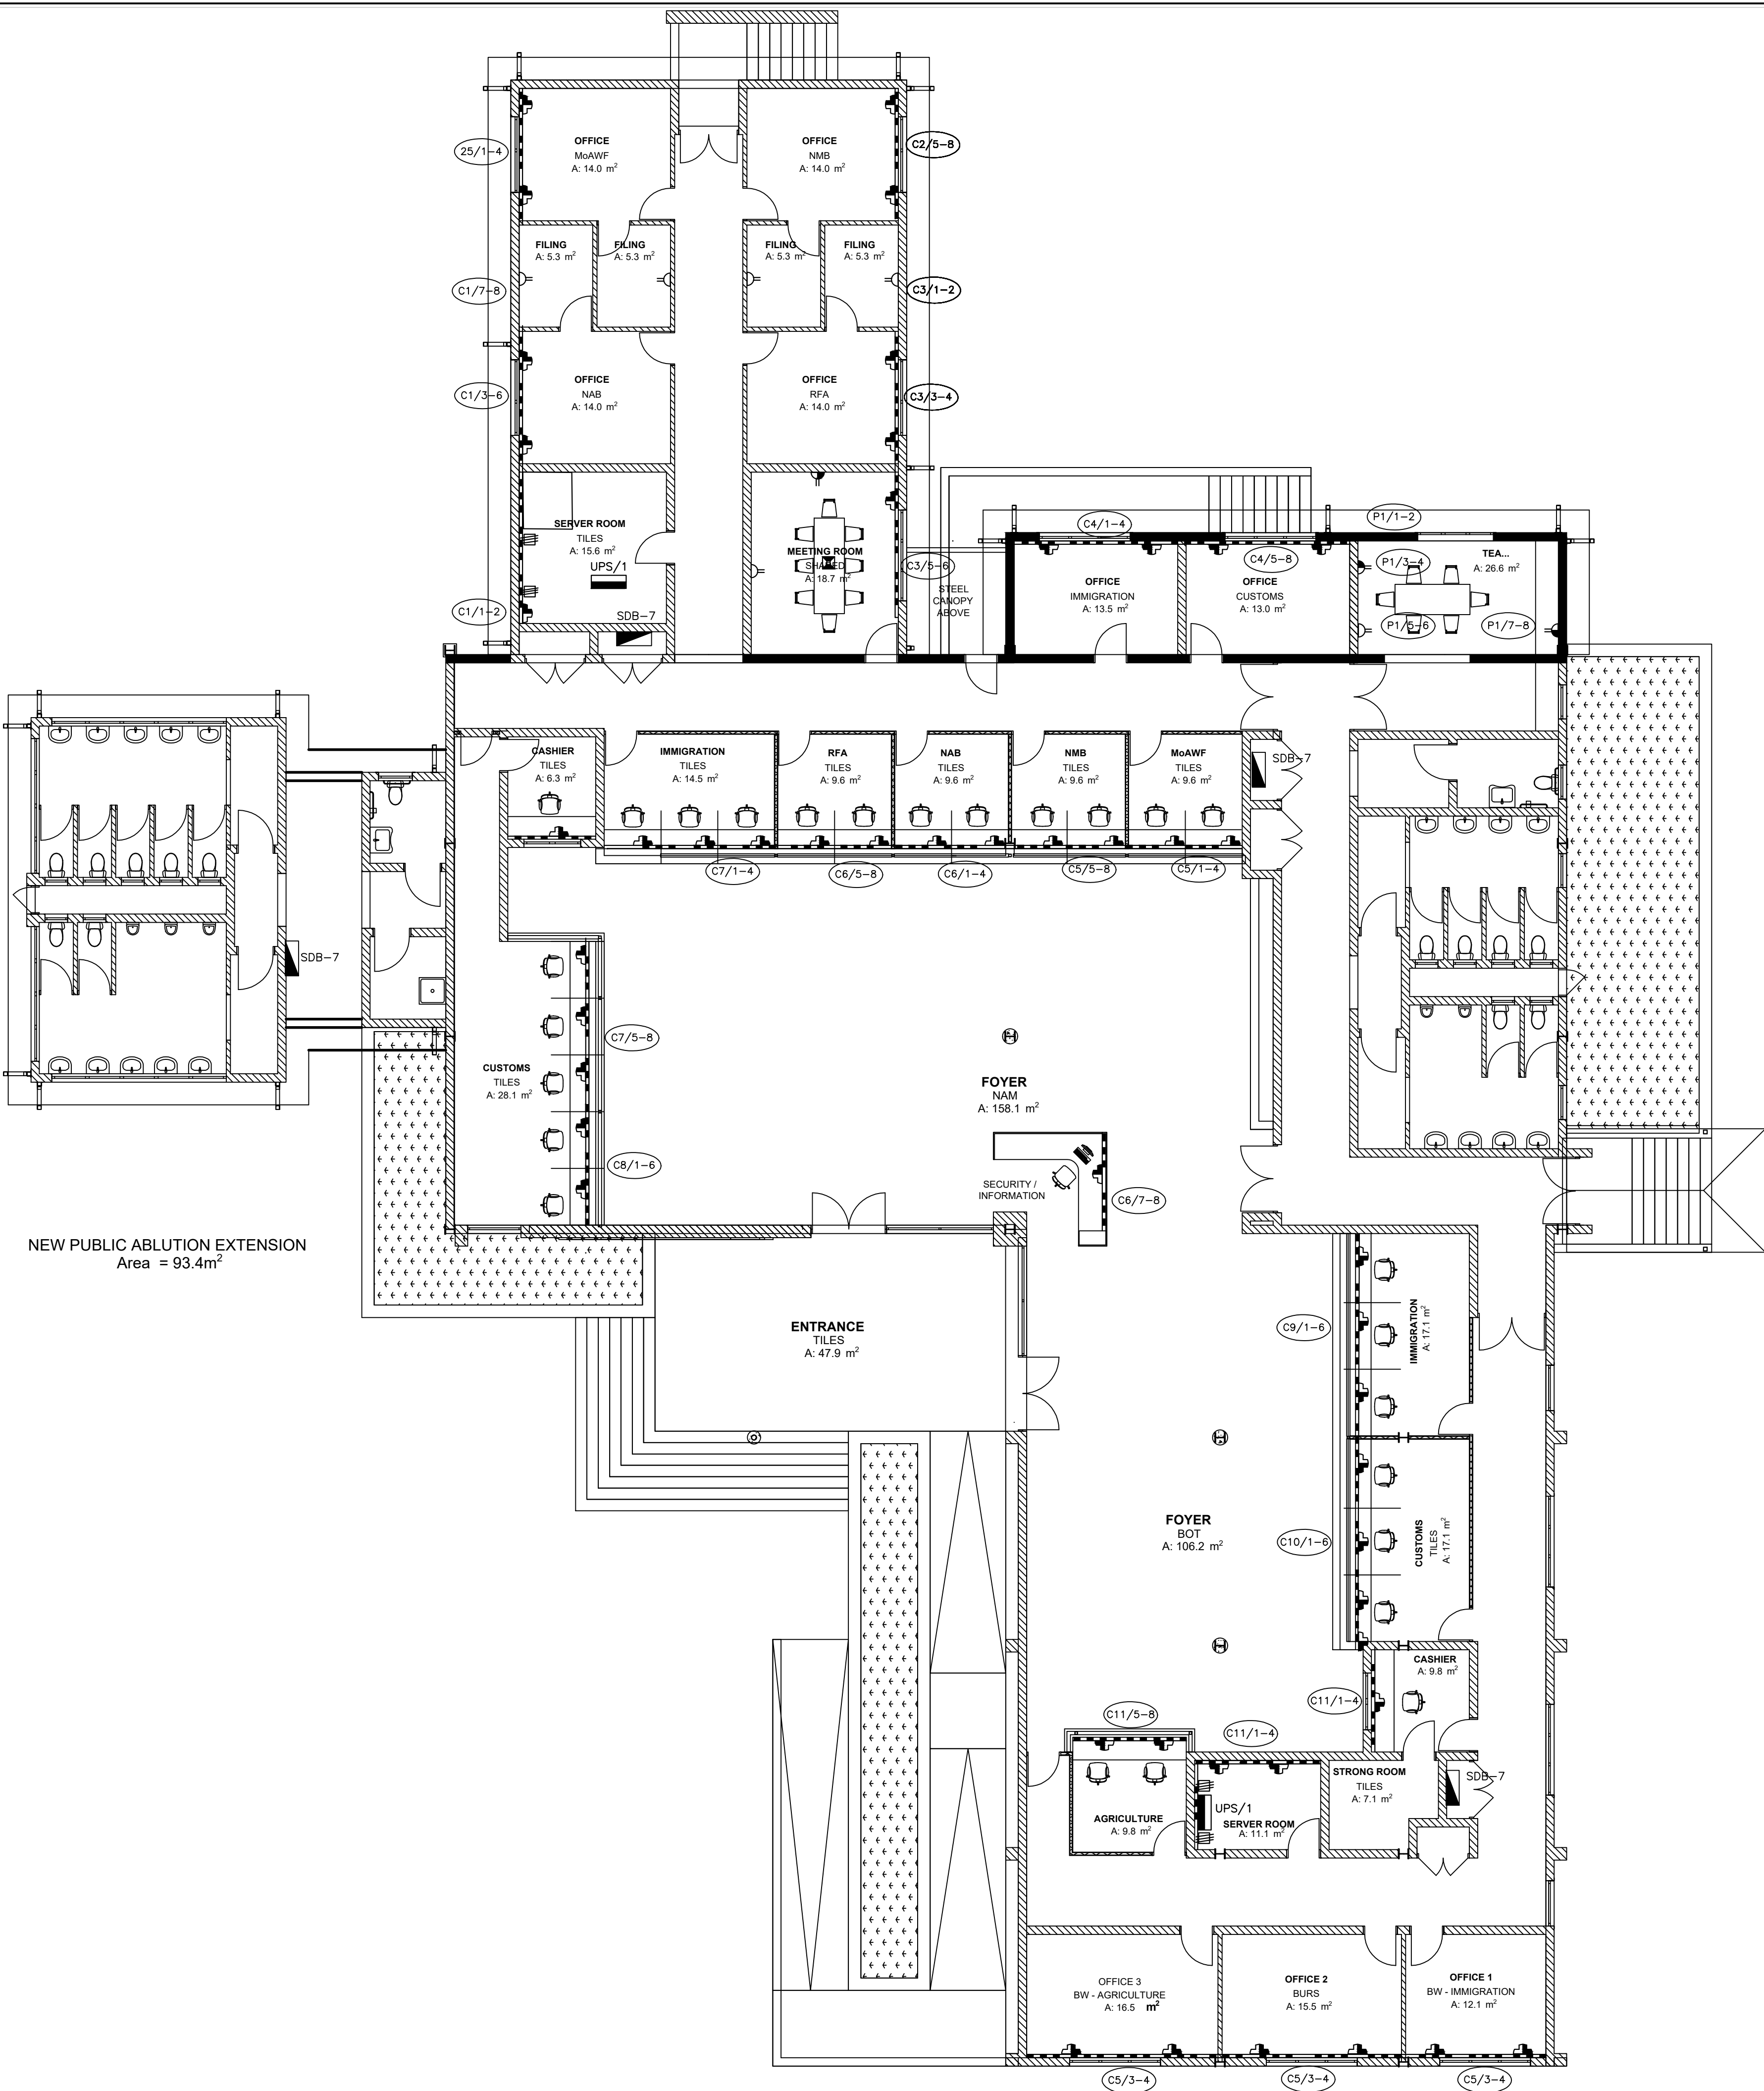

NOTES				

STOREROOM
NamRA
A: 8.6 m²

CONTROL ROOM
NamRA
A: 2.0 m²

SERVER
NamRA
A: 11.2 m²

UPS/1

OFFICE 1
NamRA
A: 16.0 m²

OFFICE 2
NAMRA
A: 12.0 m²

OFFICE 3
NAMRA
A: 12.0 m²

OFFICE 4
NAMRA
A: 12.0 m²

OFFICE 5
NAMRA
A: 12.0 m²

FILING
NamRA
A: 8.6 m²

TEA ROOM
SHARED
A: 14.9 m²


CIRCULATION AREA
TILES
A: 54.8 m²

MEETING ROOM
SHARED
A: 51.1 m²

Please park for projector in sitting area

STEEL CANOPY ABOVE

STEEL CANOPY ABOVE

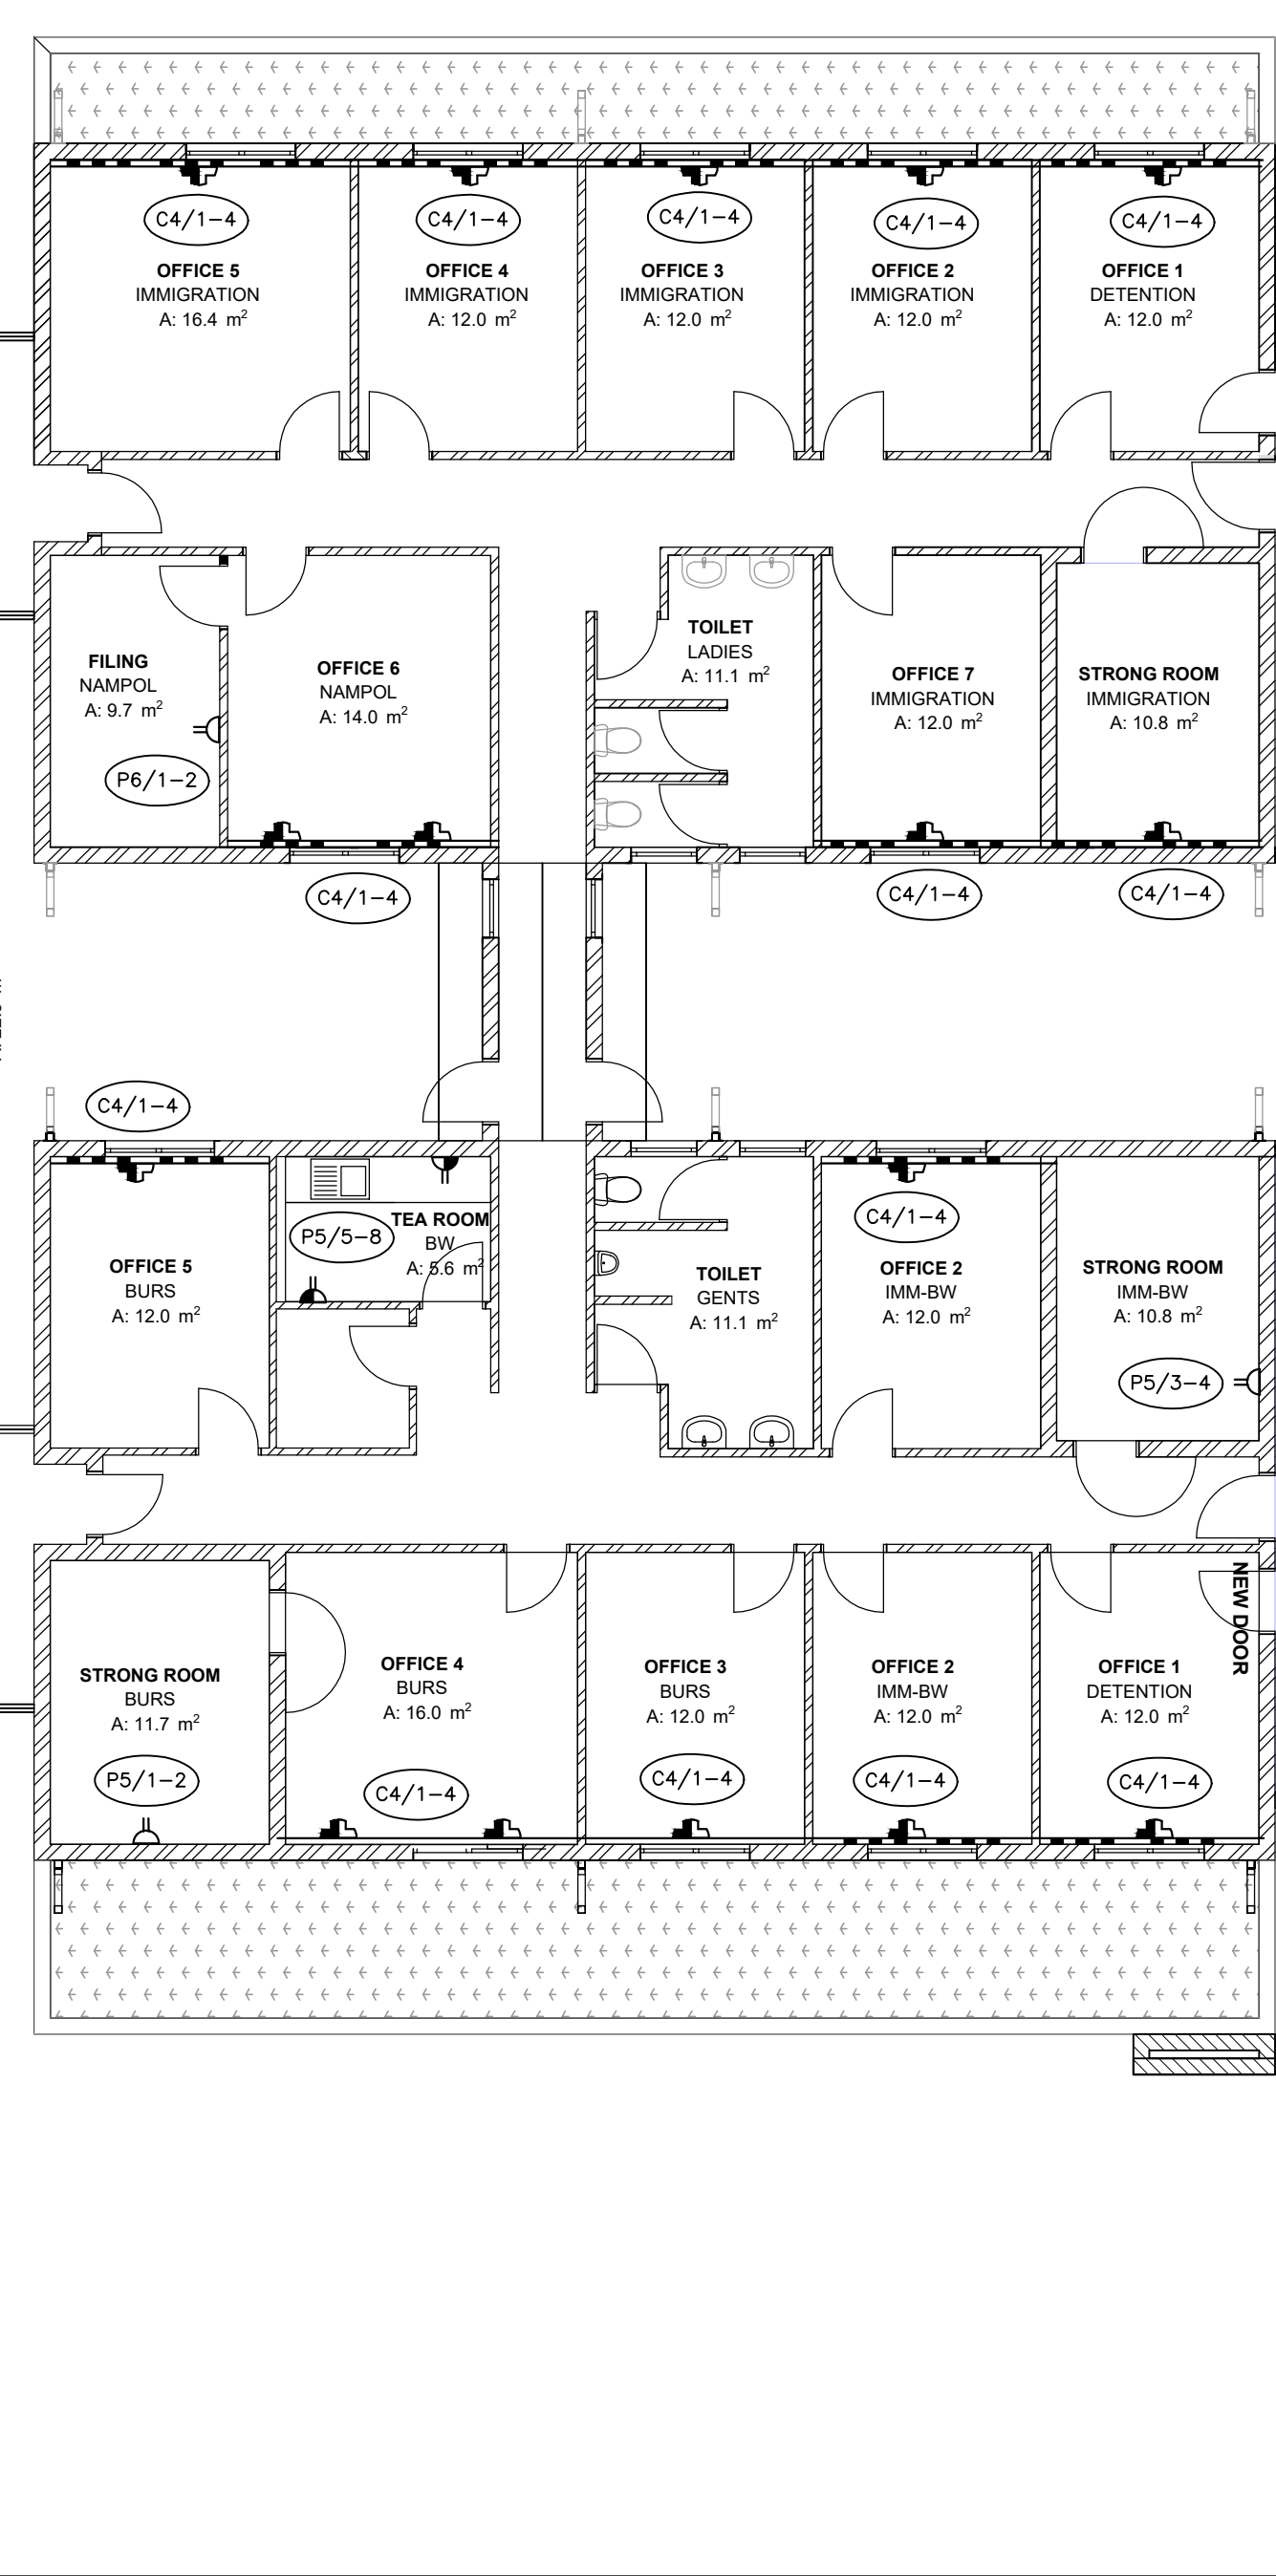

ARCHITECT Chigima Architects			P.O. Box 11257 WINDHOEK, NAMIBIA TEL: (061) 259 125 kuda@chigimaarch.com														
QUANTITY SURVEYOR P.O. Box 90680 WINDHOEK, NAMIBIA TEL: (061) 220 081 info@jongsang.com																	
CIVIL & STRUCTURAL ENGINEERS P.O. Box 21744 TEL: 220 229 959 X: 220 282 992 m@info@dekojohannesburg.com INDHDEKOEK																	
ELEC & MECH. ENGINEERS: P.O. Box 21744 TEL: 220 229 959 X: 220 282 992 m@info@dekojohannesburg.com INDHDEKOEK																	
DESIGN <table border="1" style="width: 100%; border-collapse: collapse;"> <tr> <td style="width: 16.6%;">DESIGNED</td> <td style="width: 16.6%;">RJ</td> <td style="width: 16.6%;">01/24</td> <td style="width: 16.6%;">DRAWN</td> <td style="width: 16.6%;">RJ</td> <td style="width: 16.6%;">01/24</td> </tr> <tr> <td colspan="3">PROFESSIONAL ENGINEER</td> <td>ADJ</td> <td colspan="2"></td> </tr> </table>						DESIGNED	RJ	01/24	DRAWN	RJ	01/24	PROFESSIONAL ENGINEER			ADJ		
DESIGNED	RJ	01/24	DRAWN	RJ	01/24												
PROFESSIONAL ENGINEER			ADJ														
CLIENT: NAMIBIA REVENUE AGENCY 10 JOHN MEINERT & MOKTKE STREET, WINDHOEK TEL: (061) 209 2259																	
DISCIPLINE: ELECTRICAL																	
PROJECT TITLE: REFURBISHMENT OF TRANS KALAHARI BORDER TO A ONE STOP BORDER POST																	
DRAWING TITLE: COMMERCIAL TERMINAL : SMALL POWER LAYOUT																	
SCALE: 1 : 100					A1												
CONSULTANT DRAWING NO.: D0121/E1-101					REV. 												
CLIENT DRAWING NO.:					REV. 												