




LEGEND		
SYMBOL	DESCRIPTION	QTY
	1x Ø110mm HDPE SLEEVE LAID @ 650mm BELOW N.G.L. INSTALLED FOR LOW VOLTAGE CABLE	200m
	2x Ø110mm HDPE SLEEVE LAID @ 650mm BELOW N.G.L. INSTALLED FOR LOW VOLTAGE CABLE	—
	1x Ø50mm HDPE SLEEVE LAID @ 650mm BELOW N.G.L. INSTALLED FOR SERVICE CABLES	—
	950 x 1500 x 1800 mm STANDARD TELECOMS MANHOLES.	1
	850 x 1200 x 850 mm STANDARD TELECOMS JOINTING PITS.	7
	Ø110mm HDPE SLEEVE @750mm BELOW NGL FOR CATEGORY TELECOMS	1750m
	ACCESS POINT FOR DATA / TELECOM / WIFY IN THE CEILING TO BE CONFIRMED BY THE ENGINEERS	8

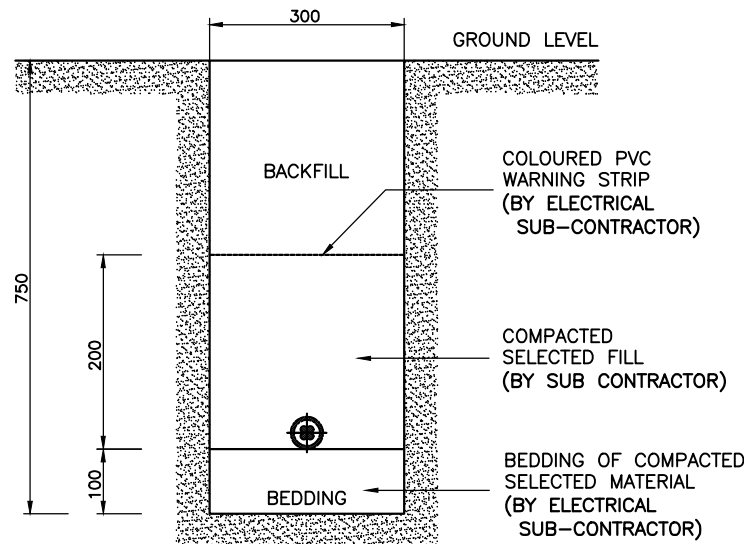

LOW VOLTAGE CABLES
AND SLEEVES TRENCH
NTS

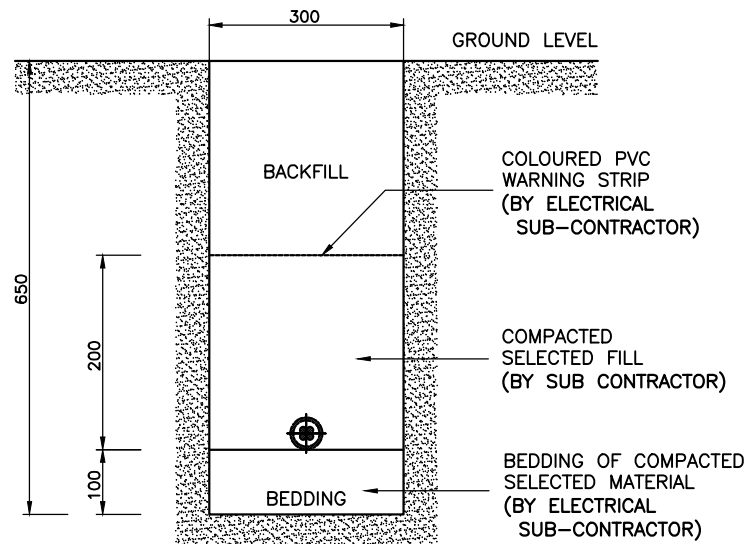

TELECOM TRENCH
NTS

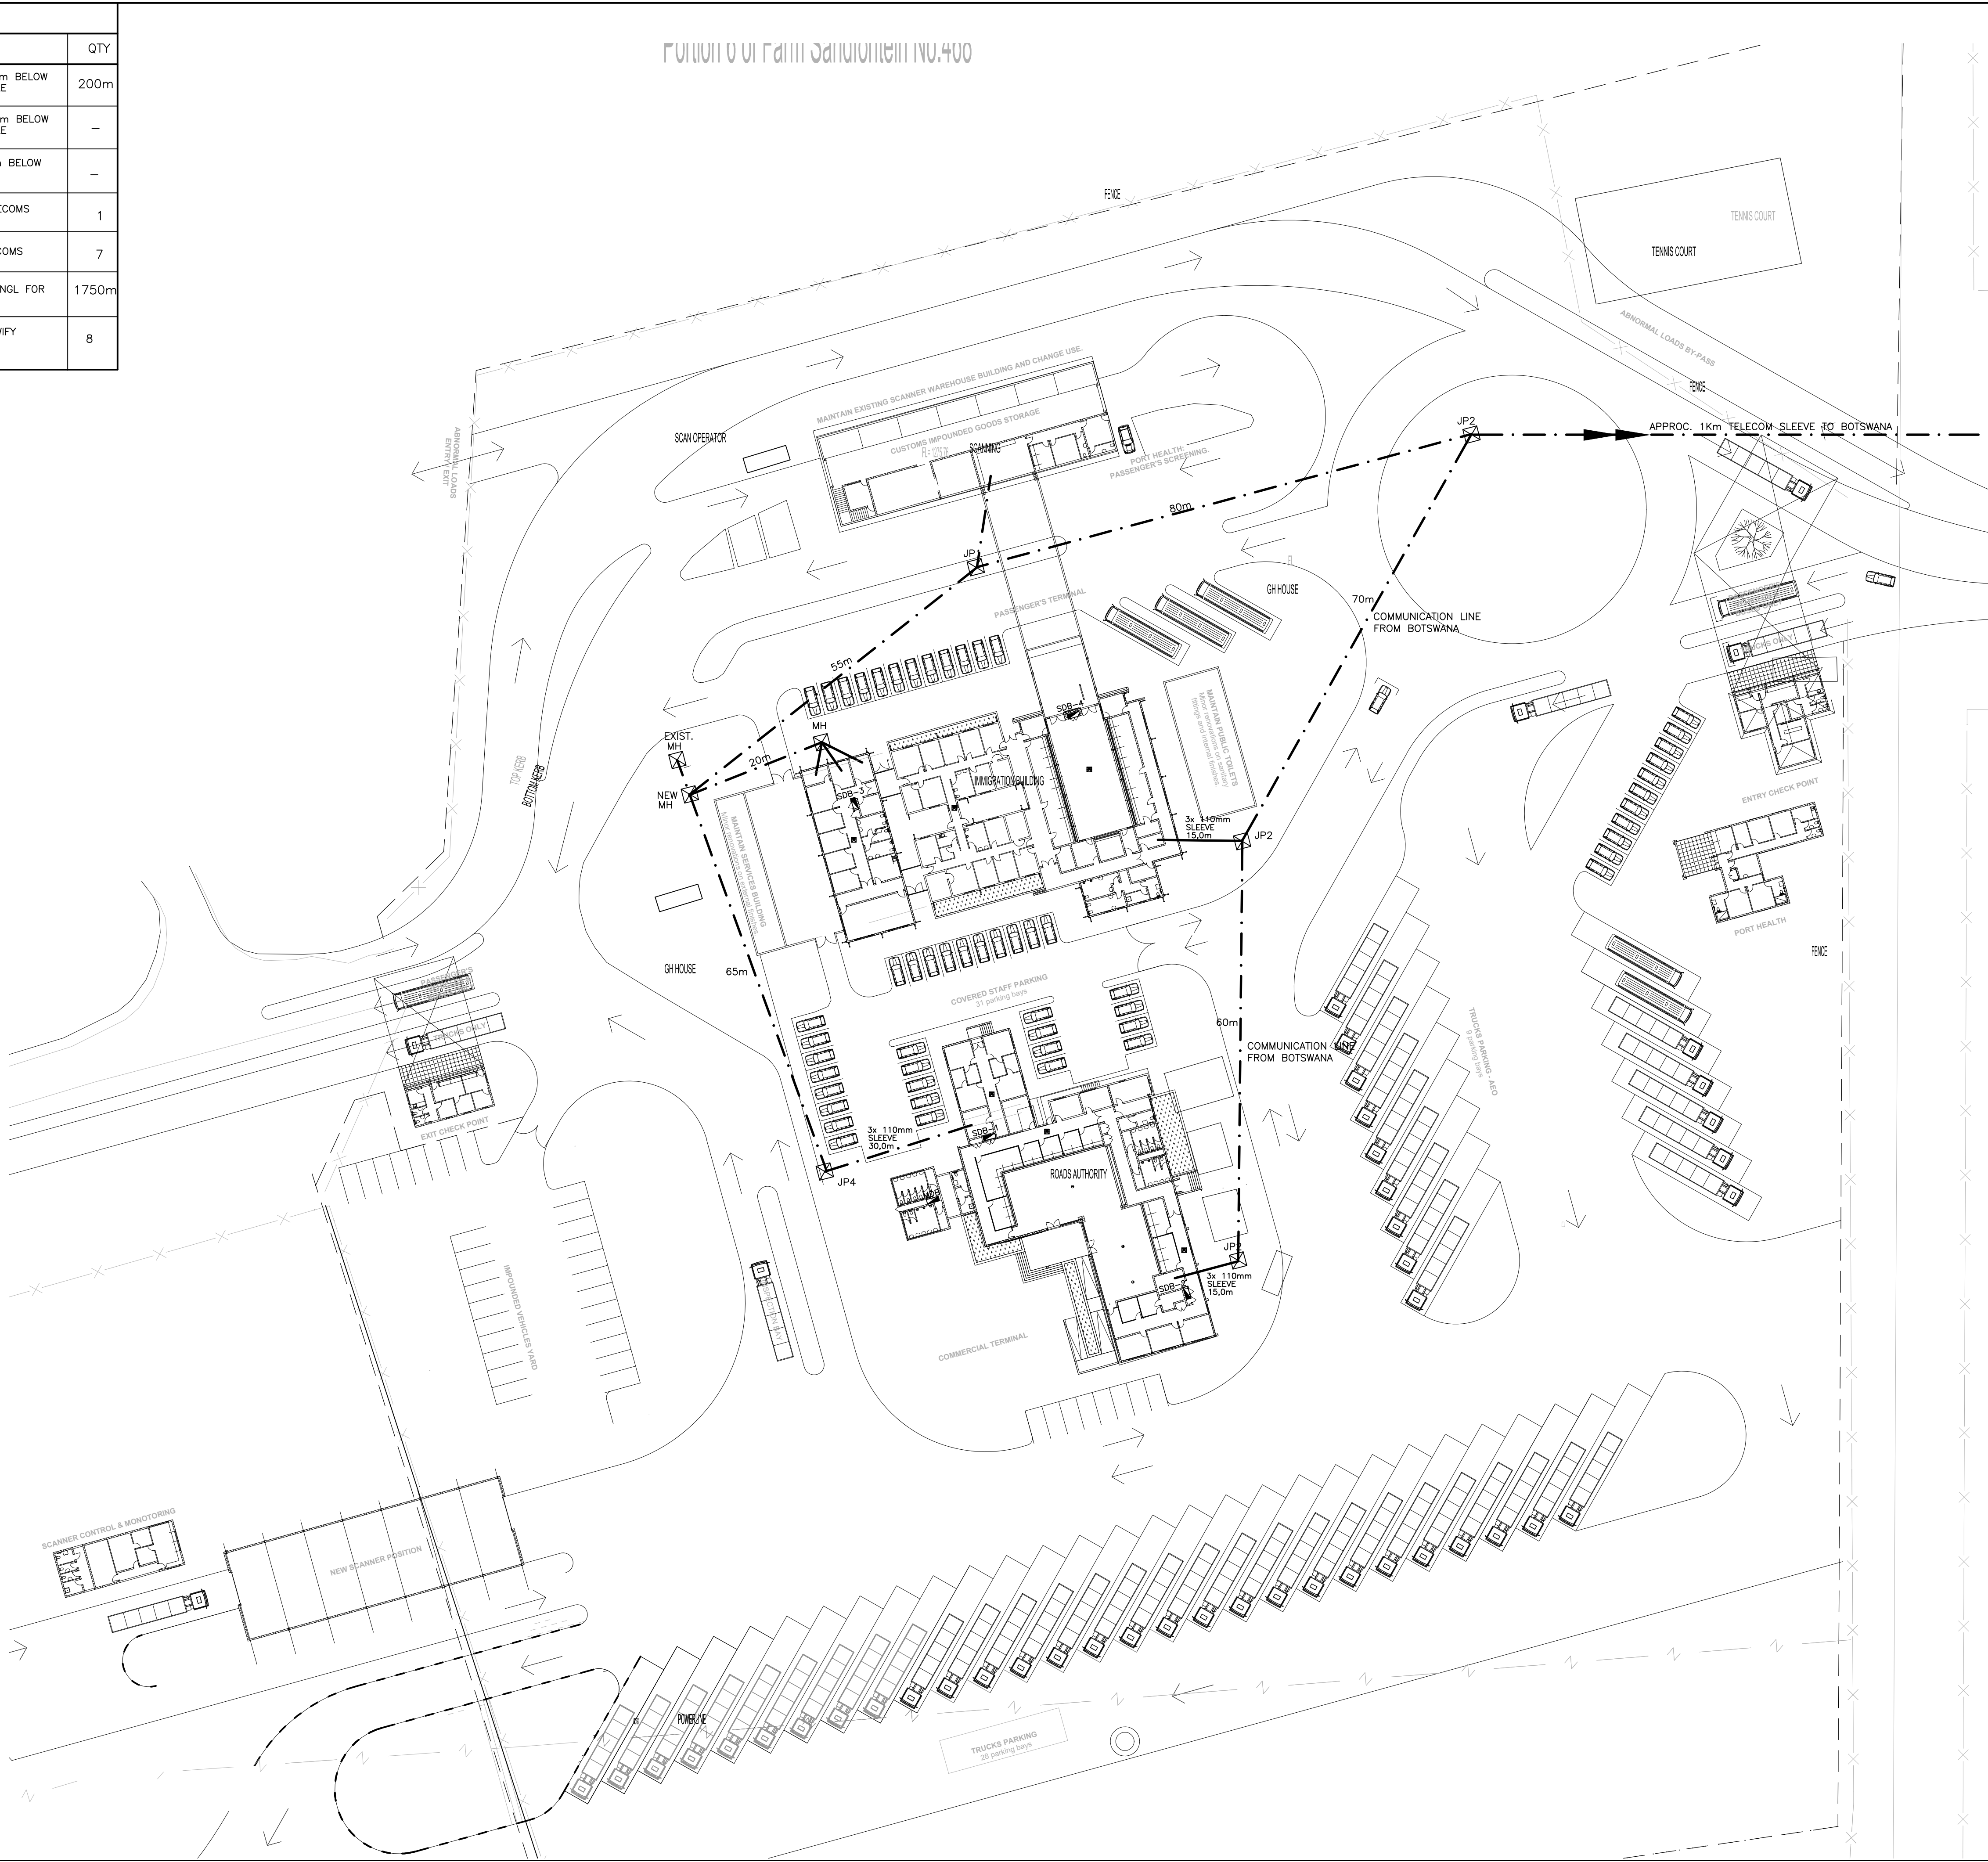

NOTES

1. THIS DRAWING SHOULD BE READ IN CONJUNCTION WITH THE RELEVANT ARCHITECTURAL, MECHANICAL & ELECTRICAL DRAWINGS.

2. INSTALLATION SHALL BE ACCORDING WITH RELEVANT SABS SPECIFICATIONS AND IN PARTICULAR SANS 10142-1, THE WIRING OF PREMISES.

3. SYMBOLS ON THIS DRAWING ARE NOT A TRUE REFLECTION OF SIZE OF ITEM/EQUIPMENT INTENDED, BUT MERELY A GRAPHICAL PRESENTATION.

FOR BIDDING
PURPOSES ONLY

No.	REVISIONS	ENG.	DATE

ARCHITECT

P.O. Box 11257
WINDHOEK, NAMIBIA
TEL: (061) 259 125
kuda@chigamaarch.com

QUANTITY SURVEYOR

P.O. Box 90680
WINDHOEK, NAMIBIA
TEL: (061) 220 081
info@jongqs.com

CIVIL & STRUCTURAL ENGINEERS

P.O. Box 21744
Tel: 061 220 959
Fax: 061 220 992
E-mail: info@dekaconsult.com
WINDHOEK

ELEC. & MECH. ENGINEERS:

P.O. Box 21744
Tel: 061 220 959
Fax: 061 220 992
E-mail: info@dekaconsult.com
WINDHOEK

DESIGN

DESIGNED	RJ	01/24	DRAWN	HFM	01/24
----------	----	-------	-------	-----	-------

PROFESSIONAL ENGINEER

ADJ

CLIENT:

NAMIBIA REVENUE AGENCY
10 JOHN MEINERT & MOLKTE STREET, WINDHOEK
TEL: (061) 209 2259

DISCIPLINE:

ELECTRICAL

PROJECT TITLE:

REFURBISHMENT OF TRANS
KALAHARI BORDER TO A ONE STOP
BORDER POST

DRAWING TITLE:

SITE PLAN
SLEEVE LAYOUT

SCALE:

1 : 500

A1

CONSULTANT DRAWING NO.:


D0121/E1-003

REV.

CLIENT DRAWING NO.:

REV.

SYMBOL LIST		
SYMBOL	DESCRIPTION	QTY
	COPPER EARTH ELECTRODE DRIVEN TO A DEPTH PREDETERMINED BY SOIL RESISTIVITY SURVEY. RESISTANCE NOT TO EXCEED 30 Ohms AT ANY SINGLE POINT	26
	TEST POINT 300mm ABOVE NATURAL GROUND LEVEL	8

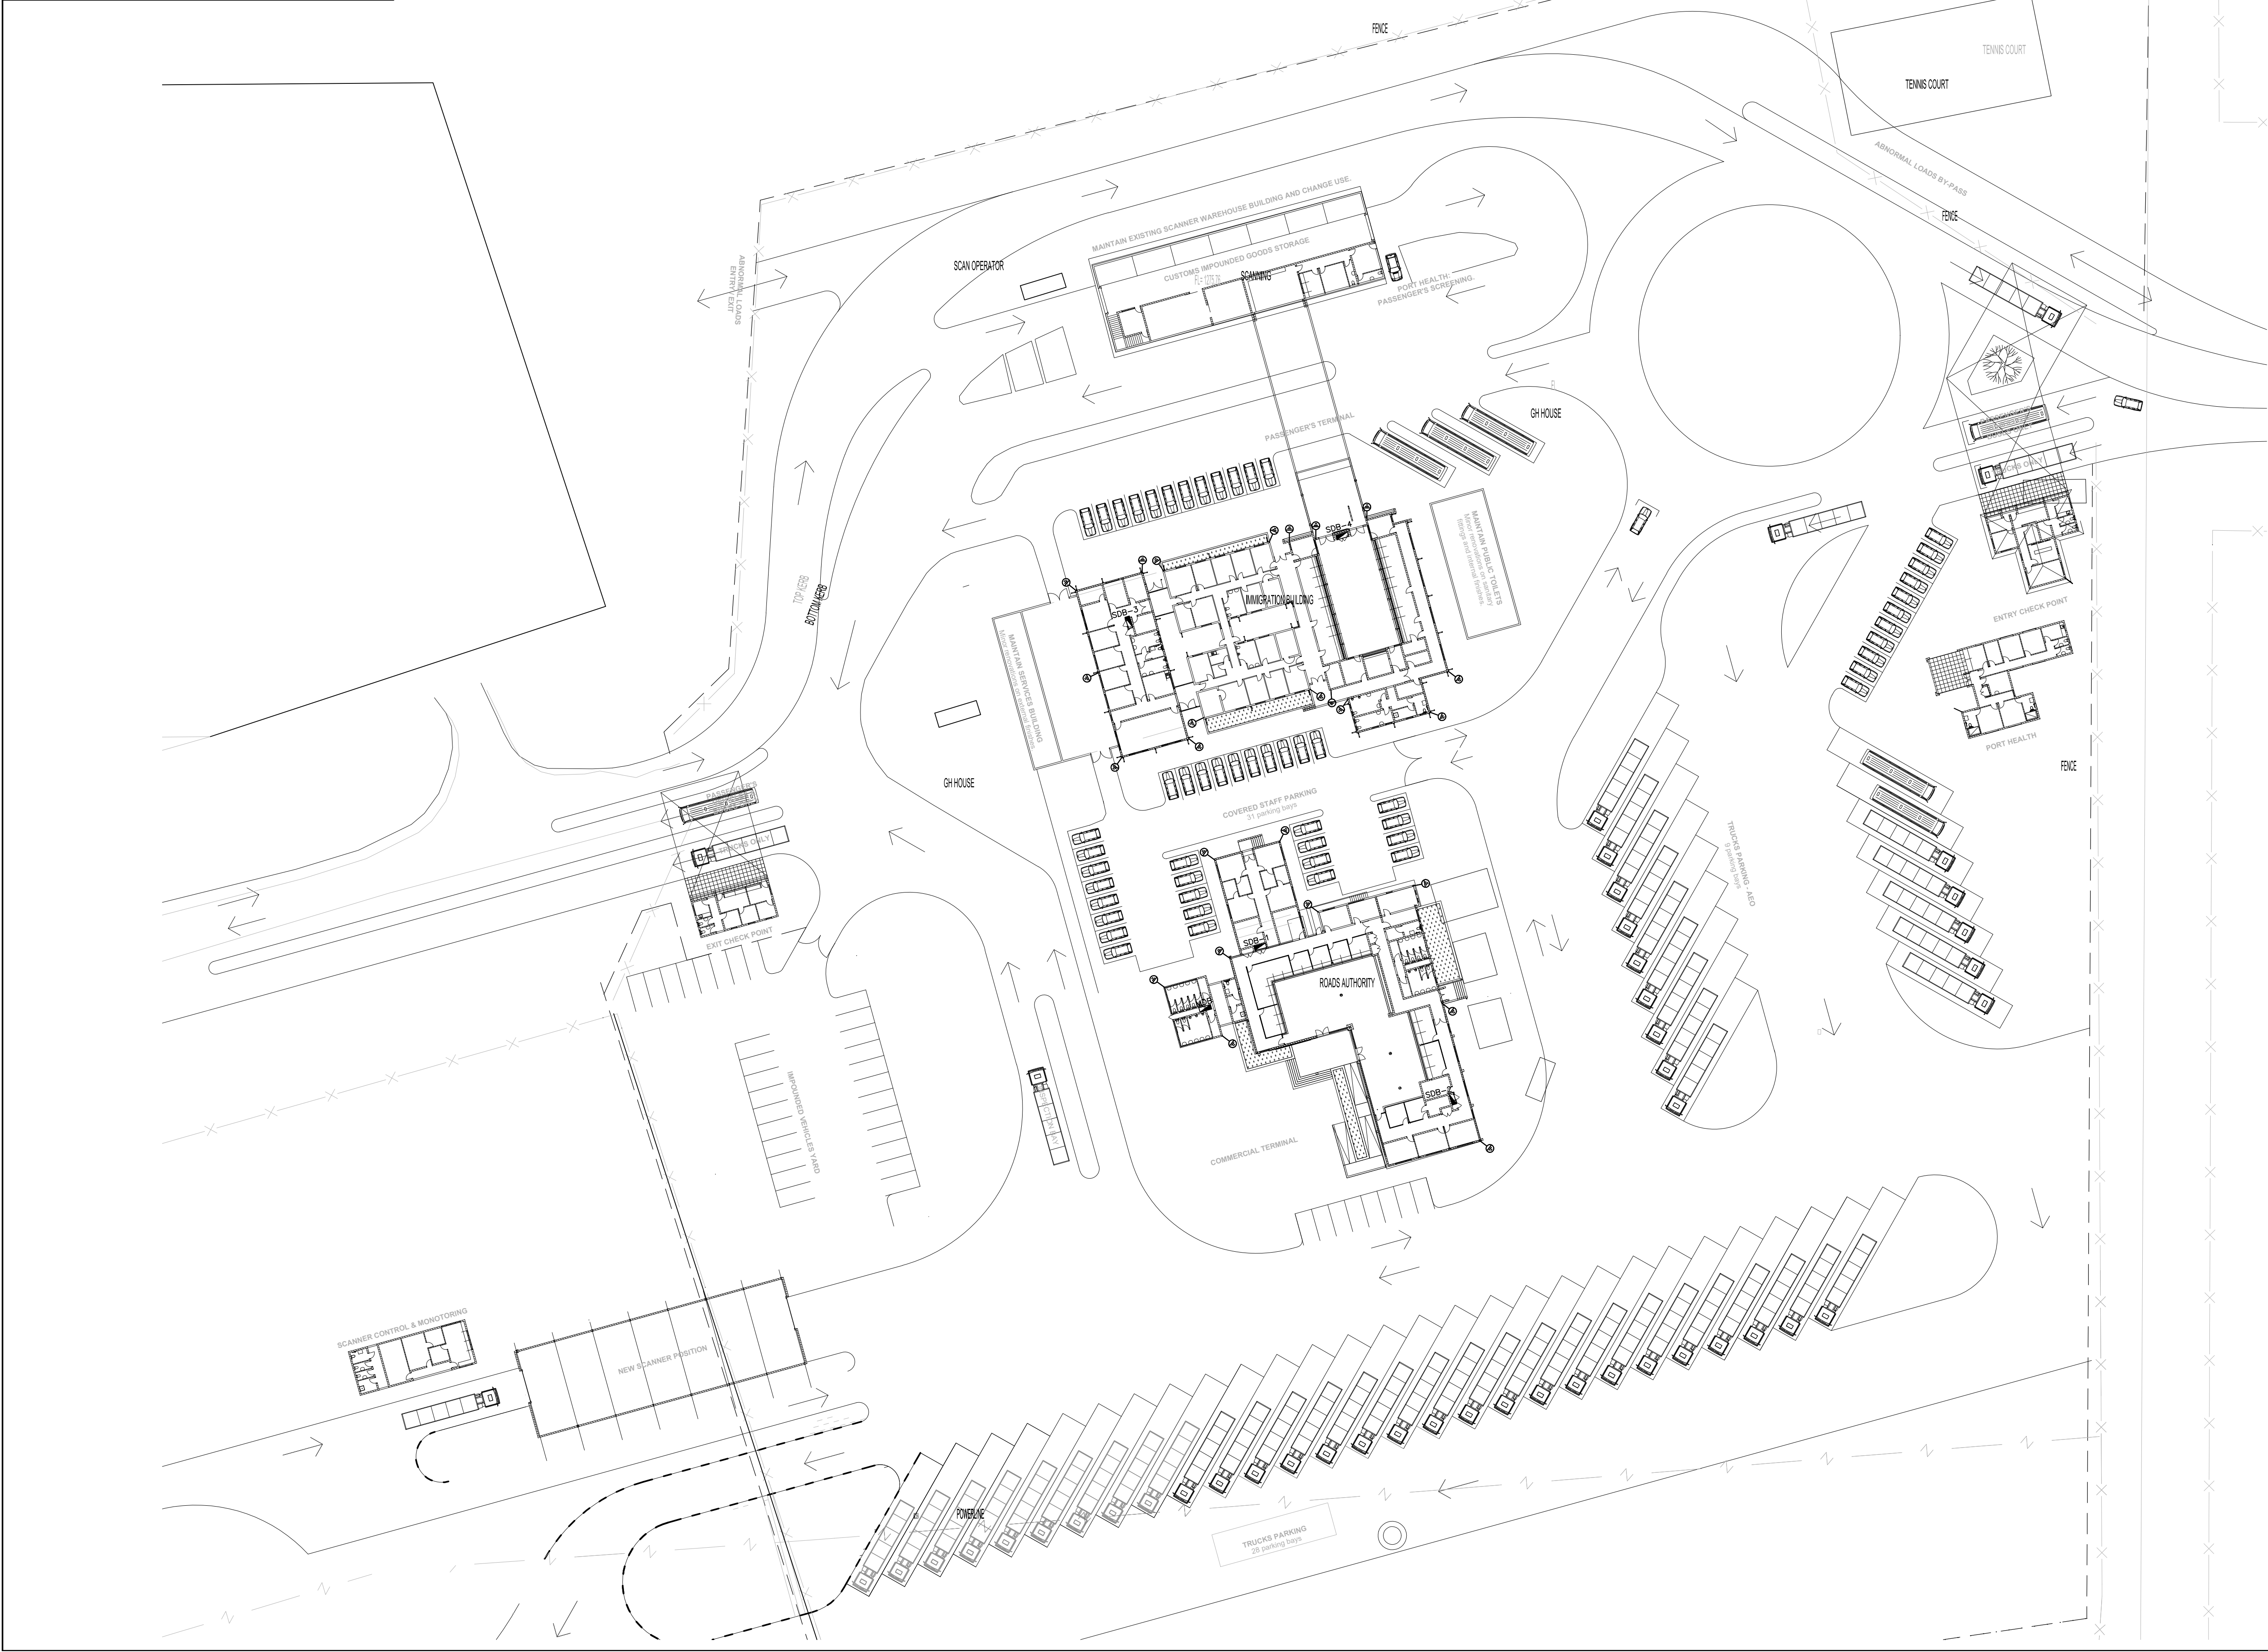

NOTES

1. THIS DRAWING SHOULD BE READ IN CONJUNCTION WITH THE RELEVANT ARCHITECTURAL, MECHANICAL & ELECTRICAL DRAWINGS.

2. INSTALLATION SHALL BE ACCORDING WITH RELEVANT SABS SPECIFICATIONS AND IN PARTICULAR SANS 10142-1, THE WIRING OF PREMISES.

3. SYMBOLS ON THIS DRAWING ARE NOT A TRUE REFLECTION OF SIZE OF ITEM/EQUIPMENT INTENDED, BUT MERELY A GRAPHICAL PRESENTATION.

FOR BIDDING PURPOSES ONLY

No.	REVISIONS	ENG.	DATE

ARCHITECT



P.O. Box 11257
WINDHOEK, NAMIBIA
TEL: (061) 259 125
kuda@chigamaarch.com

QUANTITY SURVEYOR



P.O. Box 90680
WINDHOEK, NAMIBIA
TEL: (061) 220 081
info@jongqs.com

CIVIL & STRUCTURAL ENGINEERS



P.O. Box 21744
Tel: 061 220 959
Fax: 061 220 992
E-mail: info@dekaconsult.com
WINDHOEK

ELEC. & MECH. ENGINEERS:



P.O. Box 21744
Tel: 061 220 959
Fax: 061 220 992
E-mail: info@dekaconsult.com
WINDHOEK

DESIGN

DESIGNED	RJ	01/24	DRAWN	HFM	01/24
----------	----	-------	-------	-----	-------

PROFESSIONAL ENGINEER	ADJ	
-----------------------	-----	--

CLIENT:



NAMIBIA REVENUE AGENCY
10 JOHN MEINERT & MOKETE STREET, WINDHOEK
TEL: (061) 209 2259

DISCIPLINE:

ELECTRICAL

PROJECT TITLE:

REFURBISHMENT OF TRANS KALAHARI BORDER TO A ONE STOP BORDER POST

DRAWING TITLE:

SITE PLAN
LIGHTNING LAYOUT

SCALE:

1 : 500

A1

CONSULTANT DRAWING NO.:


D0121/E1-004



REV.

CLIENT DRAWING NO.:

REV.


SYMBOL LIST				
No	SYMBOL	DESCRIPTION	TYPE	QTY
1		16A SWITCHED TWIN SOCKET-OUTLET WITH SAFETY SHUTTERS 250V. 2P + EARTH WITH SIDE CONTACTS. FLUSH MOUNTED @ 300mm AFFL.	CLIPSAL S2000 OR EQUAL	6
2		16A SWITCHED TWIN SOCKET-OUTLET WITH SAFETY SHUTTERS 250V. 2P + EARTH WITH SIDE CONTACTS. FLUSH MOUNTED @ 1200mm AFFL.	CLIPSAL S2000 OR EQUAL	2
3		RSA STANDARD 16A TWIN SOCKET-OUTLET WITH SAFETY SHUTTERS 250V. 2P+EARTH WITH SIDE CONTACTS. FLUSH MOUNTED ON POWER SKIRTING.	CLIPSAL S2000 OR EQUAL	-
4		OUTLET CLUSTER TYPE A MOUNTED ON POWER SKIRTING WITH 2x RSA STANDARD 16A SOCKET-OUTLET + 1x RJ45 DATA/COMPUTER NETWORK POINT, SHIELDED. SUITABLE FOR CATEGORY 6, FOR 10/250MB FAST ETHERNET NETWORKS + 1x RJ45 TELEPHONE SOCKET + 1x RSA STANDARD 16A SWITCHED DEDICATED SOCKET OUTLET. POWER SKIRTING WITH SAFETY SHUTTERS 250V.	CABSTRUT CLASSIC GC/2 OR EQUAL	54
5		ROUND BOX FOR AC CONTROLLER		-
6		INTERCOM. MAKE PROVISION FOR INTERCONNECTING INTERCOM CABLE WIRE WAY AND 60mm ROUND BOX AT 2300AFFL. ALL BUILDINGS TO CONNECT BACK TO ADMIN HEADMASTER OFFICE VIA 32mm SLEEVE		-
7		MULTI COMPARTMENT FLEXIBLE POWER SKIRTING MOUNTED AT FFL. COMPLETE WITH SNAP-ON COVERS, ELBOWS, END CAPS etc. DIMS. OF AT LEAST 150mm x 50mm.	CABSTRUT CLASSIC GC/2 OR EQUAL	95m
8		ROTARY WALL-MOUNTING ISOLATOR SWITCH WITH RED PADLOCKABLE KNOB ON YELLOW FLANGE. DP 16A, 32A OR 63A. IP-65. RATING AS SHOWN	GEWISS GW 70431/4/7 OR SIMILAR APPROVED	-
9		ROTARY WALL-MOUNTING ISOLATOR SWITCH WITH RED PADLOCKABLE KNOB ON YELLOW FLANGE. TP 16A, 20A, 32A OR 63A. IP-65.	GEWISS GW 70431/4/7 OR SIMILAR APPROVED	4
10		EPOXY COATED, SHEETMETAL POWER DISTRIBUTION ENCLOSURE. FLUSH MOUNTED @1400mm AFFL.	GEM OR SIMILAR APPROVED	2
11		RECESSED FLOOR OF DESK SOCKET OUTLET CLUSTER WITH 2x RSA STANDARD 16A SOCKET-OUTLET + 1xRJ45 DATA/COMPUTER NETWORK POINT, SHIELDED. SUITABLE FOR CATEGORY 6A, FOR 10/100MB FAST ETHERNET NETWORKS + 1xRJ45 TELEPHONE SOCKET + 1X RSA STANDARD 16A SWITCHED DEDICATED SOCKET OUTLET. WITH SAFETY SHUTTERS 250V.	CABSTRUT CLASSIC GC/2 OR EQUAL	1

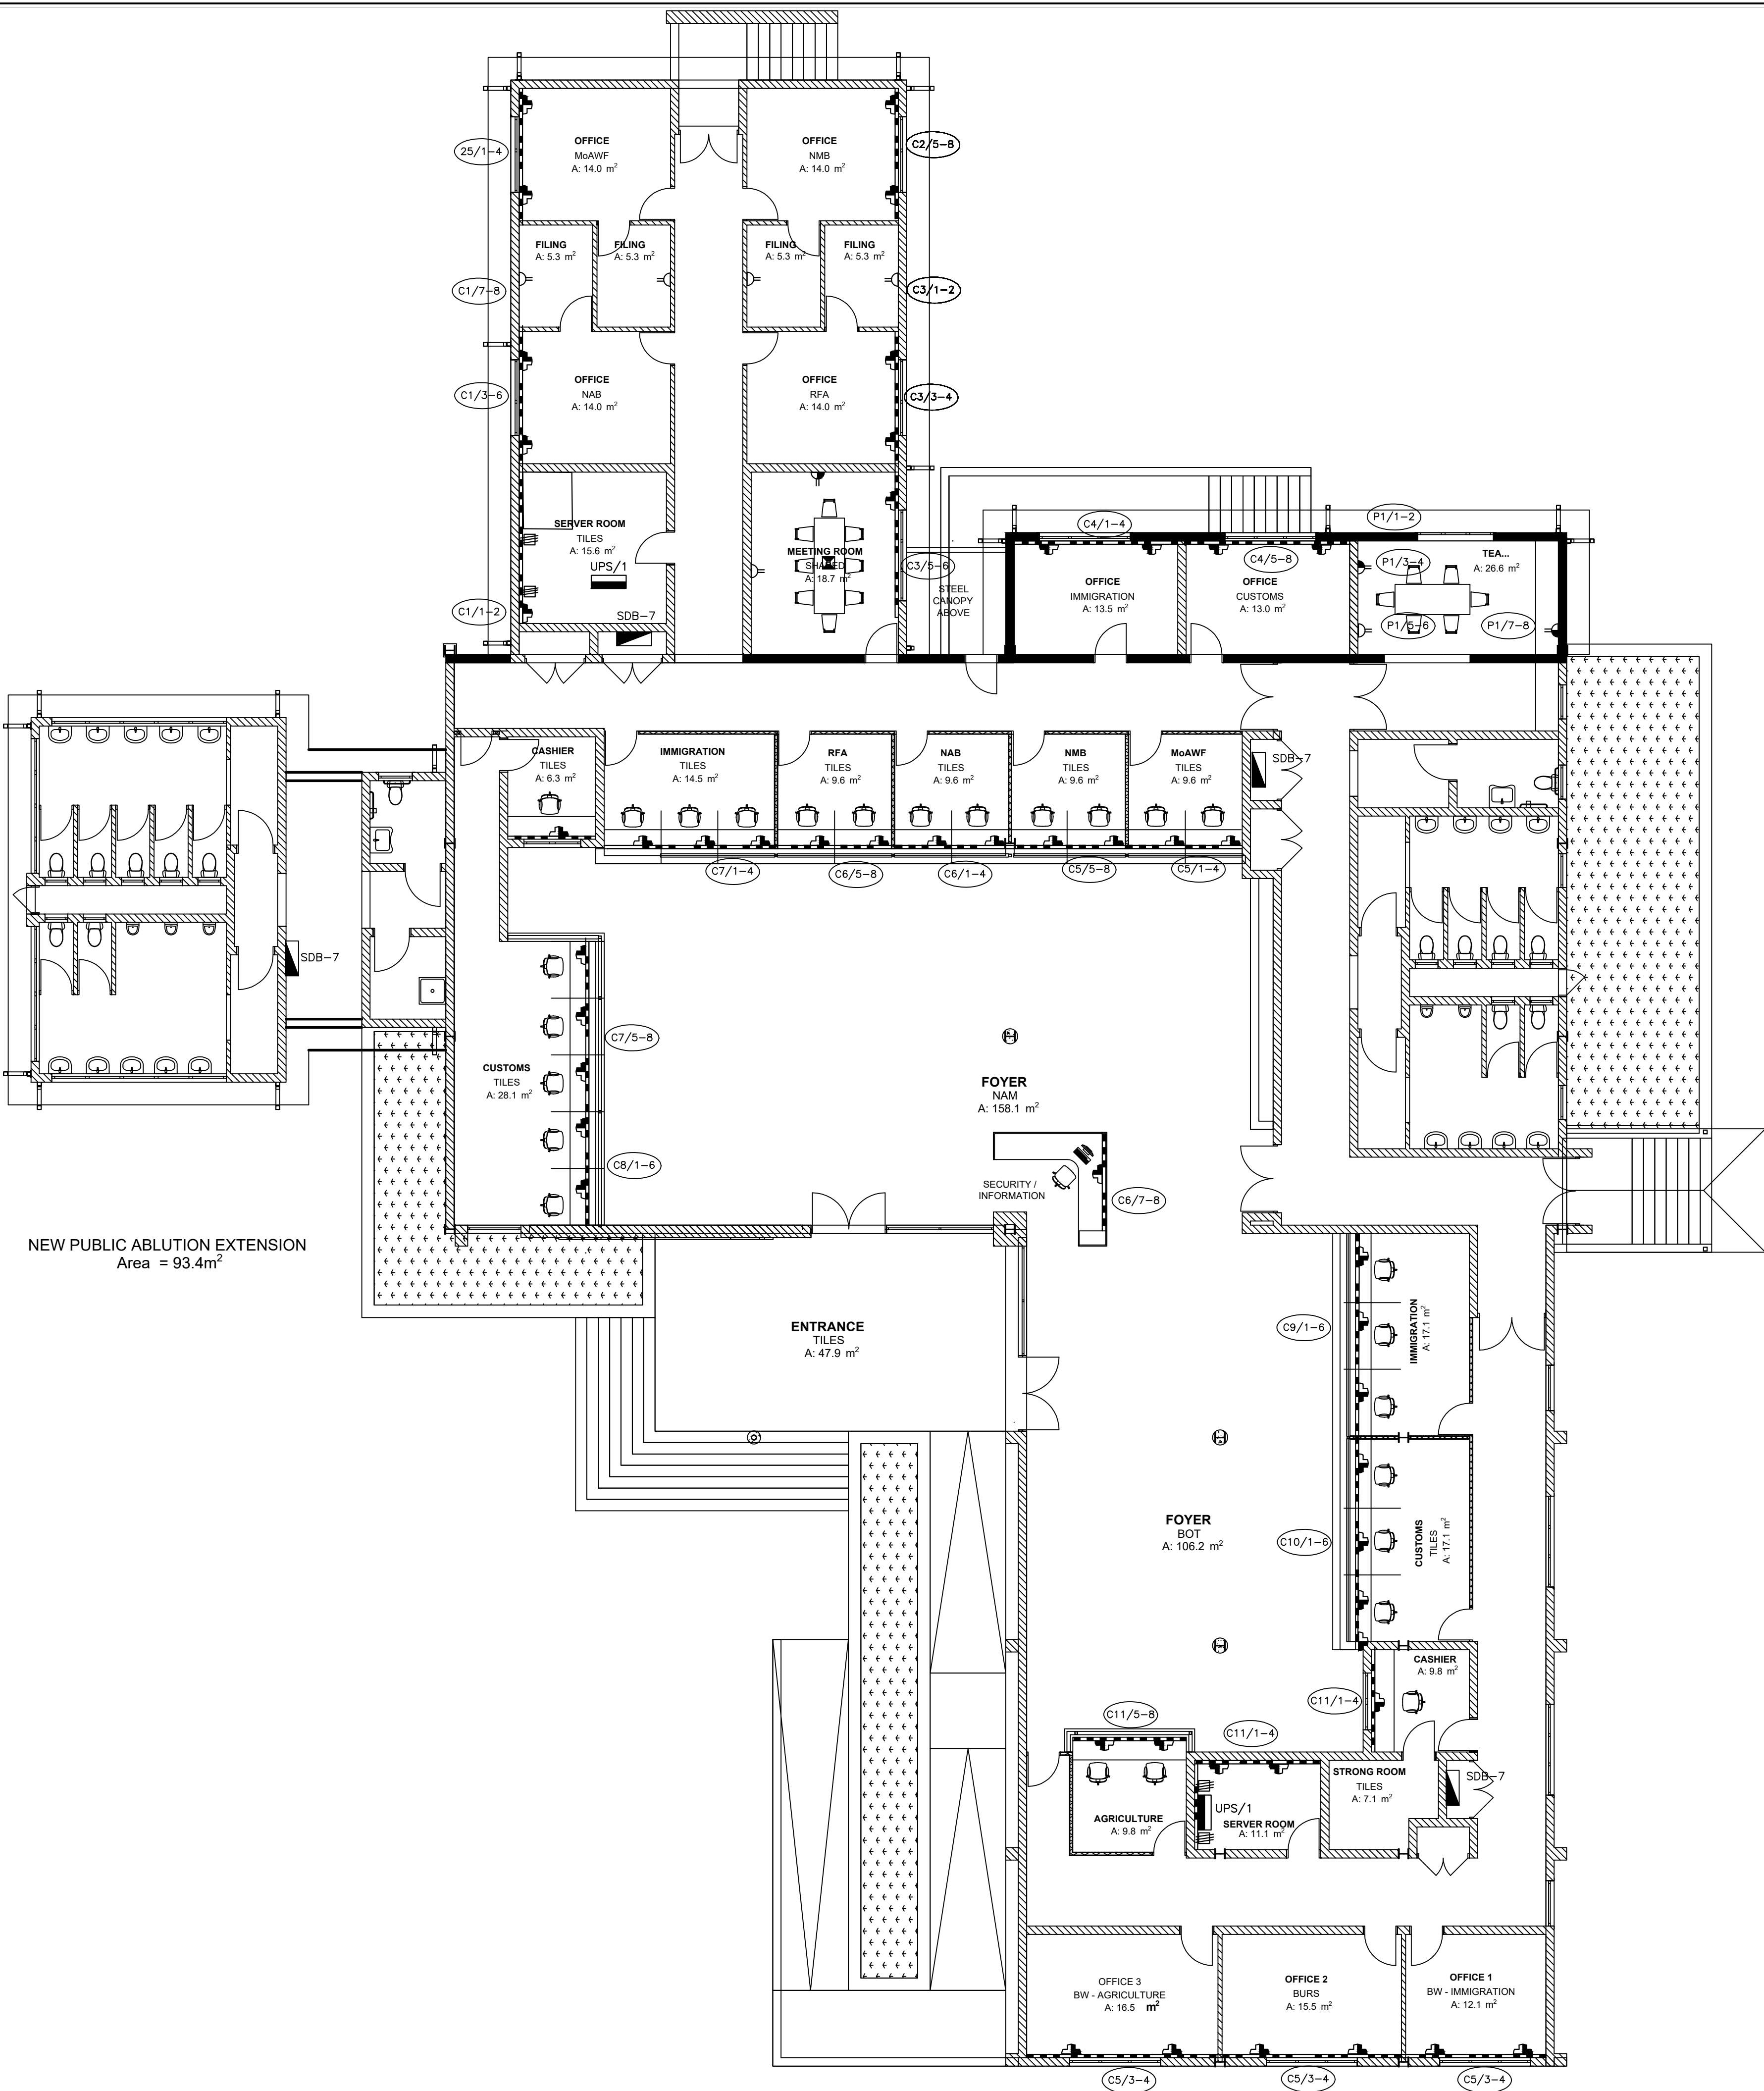

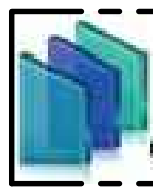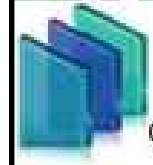NOTES				
FOR BIDDING PURPOSES ONLY				
No.	REVISIONS		ENG.	DATE
ARCHITECT				
		P.O. Box 11257 WINDHOEK, NAMIBIA TEL: (061) 259 125 kuda@chigamaarch.com		
QUANTITY SURVEYOR				
		P.O. Box 90680 WINDHOEK, NAMIBIA TEL: (061) 220 081 info@jongqs.com		
CIVIL & STRUCTURAL ENGINEERS				
		P.O. Box 21744 Tel: 061 220 959 Fax: 061 220 992 E-mail: info@dekaconsult.com		
ELEC & MECH. ENGINEERS:				
		P.O. Box 21744 Tel: 061 220 959 Fax: 061 220 992 E-mail: info@dekaconsult.com WINDHOEK		
DESIGN				
DESIGNED	RJ	01/24	DRAWN	RJ 01/24
PROFESSIONAL ENGINEER		ADJ		
CLIENT:				
				
NAMIBIA REVENUE AGENCY 10 JOHN MEINERT & MOLKTE STREET, WINDHOEK TEL: (061) 209 2259				
DISCIPLINE: ELECTRICAL				
PROJECT TITLE: REFURBISHMENT OF TRANS KALAHARI BORDER TO A ONE STOP BORDER POST				
DRAWING TITLE: COMMERCIAL TERMINAL : SMALL POWER LAYOUT				
SCALE: 1 : 100				A1
CONSULTANT DRAWING NO.: D0121/E1-101				REV. 
CLIENT DRAWING NO.:				REV. 


SYMBOL LIST				
No	SYMBOL	DESCRIPTION	TYPE	QTY
1		PROVINCE LIGHTING VERIS RECESSED LED 30W (600 x 600)	VERIS/6x6/80/40/30 OR SIMILAR APPROVED	78
2		PROVINCE LIGHTING AEGEON RECESSED LED DOWNLIGHTS 12W	AEGEON 130/80/40/15 OR SIMILAR APPROVED	187
3		PROVINCE LIGHTING AEGEON RECESSED LED DOWNLIGHTS 20W	AEGEON 170/80/40/20 OR SIMILAR APPROVED	38
4		PROVINCE LIGHTING SAXA TRIPROOF LED BATTEN 36W	SAXA/11/83/40/36 OR SIMILAR APPROVED	16
5		WALL / SURFACE MOUNTABLE LIGHT FITTING, COBALT SQUARE 15W LED, 1650 LUMENS, 4000K, 300mm x 300mm BLACK IP65 BULKHEAD, OR SIMILAR APPROVED		25
6		220V, 16A SINGLE LEVER ONE-WAY LIGHT SWITCH ON 100x100x50mm FLUSH STEEL DRAWBOX. COLOUR: WHITE COMPLETE WITH ALL ACCESSORIES @ 1200mm AFFL.	CLIPSAL S2000 OR SIMILAR APPROVED	
7		220V, 16A SINGLE LEVER TWO-WAY LIGHT SWITCH ON 100x100x50mm FLUSH STEEL DRAWBOX. COLOUR: WHITE COMPLETE WITH ALL ACCESSORIES @ 1200mm AFFL.	CLIPSAL S2000 OR SIMILAR APPROVED	
7		PHOTO-CELL MOUNTED @2400m AFFL.	CLIPSAL S2000 OR SIMILAR APPROVED	2
7		BERNE LED FLOODLIGHT, WALL/SURFACE MOUNTED LED LUMINAIRE, ALUMINIUM, CLEAR TEMPERED GLASS, IP65, FRAME COLOUR: BLACK, 70W OR SIMILAR APPROVED		6

NEW OFFICE BLOCK
Area = 2829m²

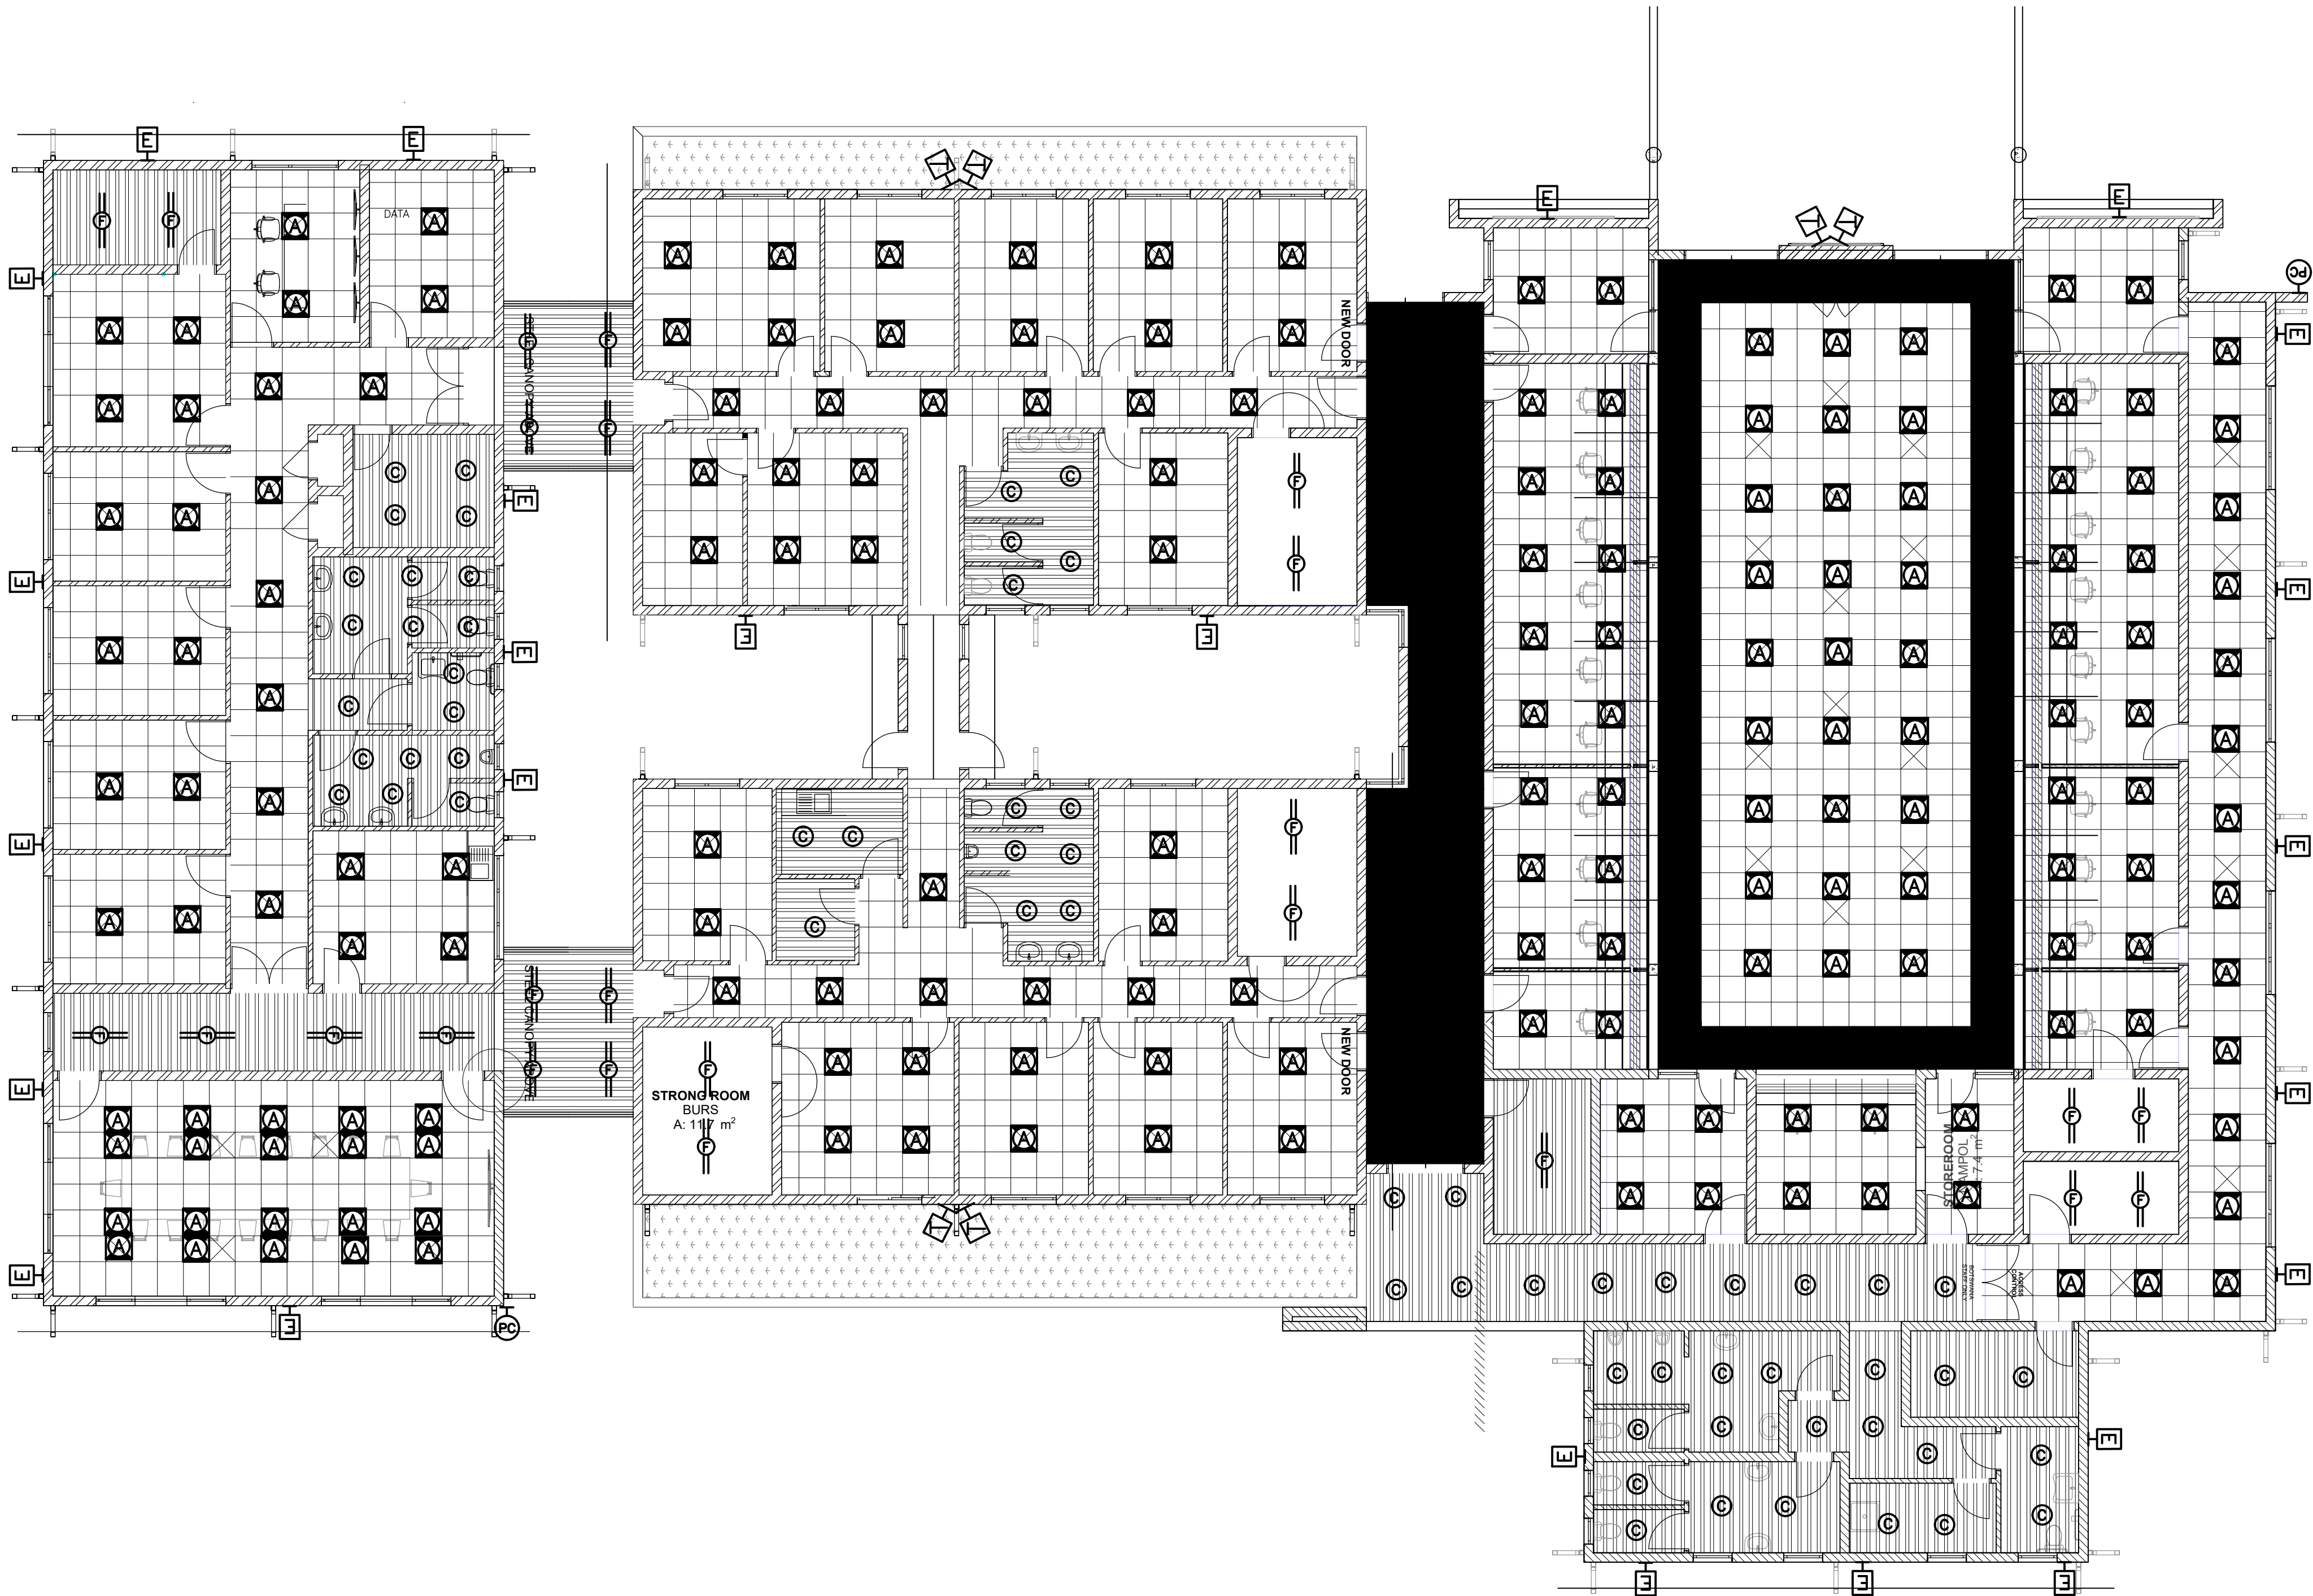

NOTES		
1. THIS DRAWING SHOULD BE READ IN CONJUNCTION WITH THE RELEVANT ARCHITECTURAL, MECHANICAL & ELECTRICAL DRAWINGS.		
2. INSTALLATION SHALL BE ACCORDING WITH RELEVANT SABS SPECIFICATIONS AND IN PARTICULAR SANS 10142-1, THE WIRING OF PREMISES.		
3. SYMBOLS ON THIS DRAWING ARE NOT A TRUE REFLECTION OF SIZE OF ITEM/EQUIPMENT INTENDED, BUT MERELY A GRAPHICAL PRESENTATION.		
FOR BIDDING PURPOSES ONLY		
No.	REVISIONS	ENG. DATE
ARCHITECT		
		P.O. Box 11257 WINDHOEK, NAMIBIA TEL: (061) 259 125 kuda@chigamaarch.com
QUANTITY SURVEYOR		
		P.O. Box 90680 WINDHOEK, NAMIBIA TEL: (061) 220 081 info@jongqs.com
CIVIL & STRUCTURAL ENGINEERS		
		P.O. Box 21744 Tel: 061 220 959 Fax: 061 220 992 E-mail: info@dekaconsult.com WINDHOEK
ELEC & MECH. ENGINEERS:		
		P.O. Box 21744 Tel: 061 220 959 Fax: 061 220 992 E-mail: info@dekaconsult.com WINDHOEK
DESIGN		
DESIGNED	RJ	01/24
DRAWN	RJ	01/24
PROFESSIONAL ENGINEER		ADJ
CLIENT:		
NAMIBIA REVENUE AGENCY 10 JOHN MEINERT & MOKETE STREET, WINDHOEK TEL: (061) 209 2259		
DISCIPLINE: ELECTRICAL		
PROJECT TITLE: REFURBISHMENT OF TRANS KALAHARI BORDER TO A ONE STOP BORDER POST		
DRAWING TITLE: PASSENGERS TERMINAL : LIGHTING LAYOUT		
SCALE: 1 : 100		A1
CONSULTANT DRAWING NO.: D0121/E1-200		REV. .
CLIENT DRAWING NO.:		REV. .

SYMBOL LIST				
NO	SYMBOL	DESCRIPTION	TYPE	QTY
1	(R)	SOLAR FLOODLIGHTS WITH 6m POLES MOUNTED 5.5m FROM GROUND LEVEL		15
	(P)	SOLAR STREETLIGHTS WITH 6m POLES MOUNTED 5m FROM GROUND LEVEL		10

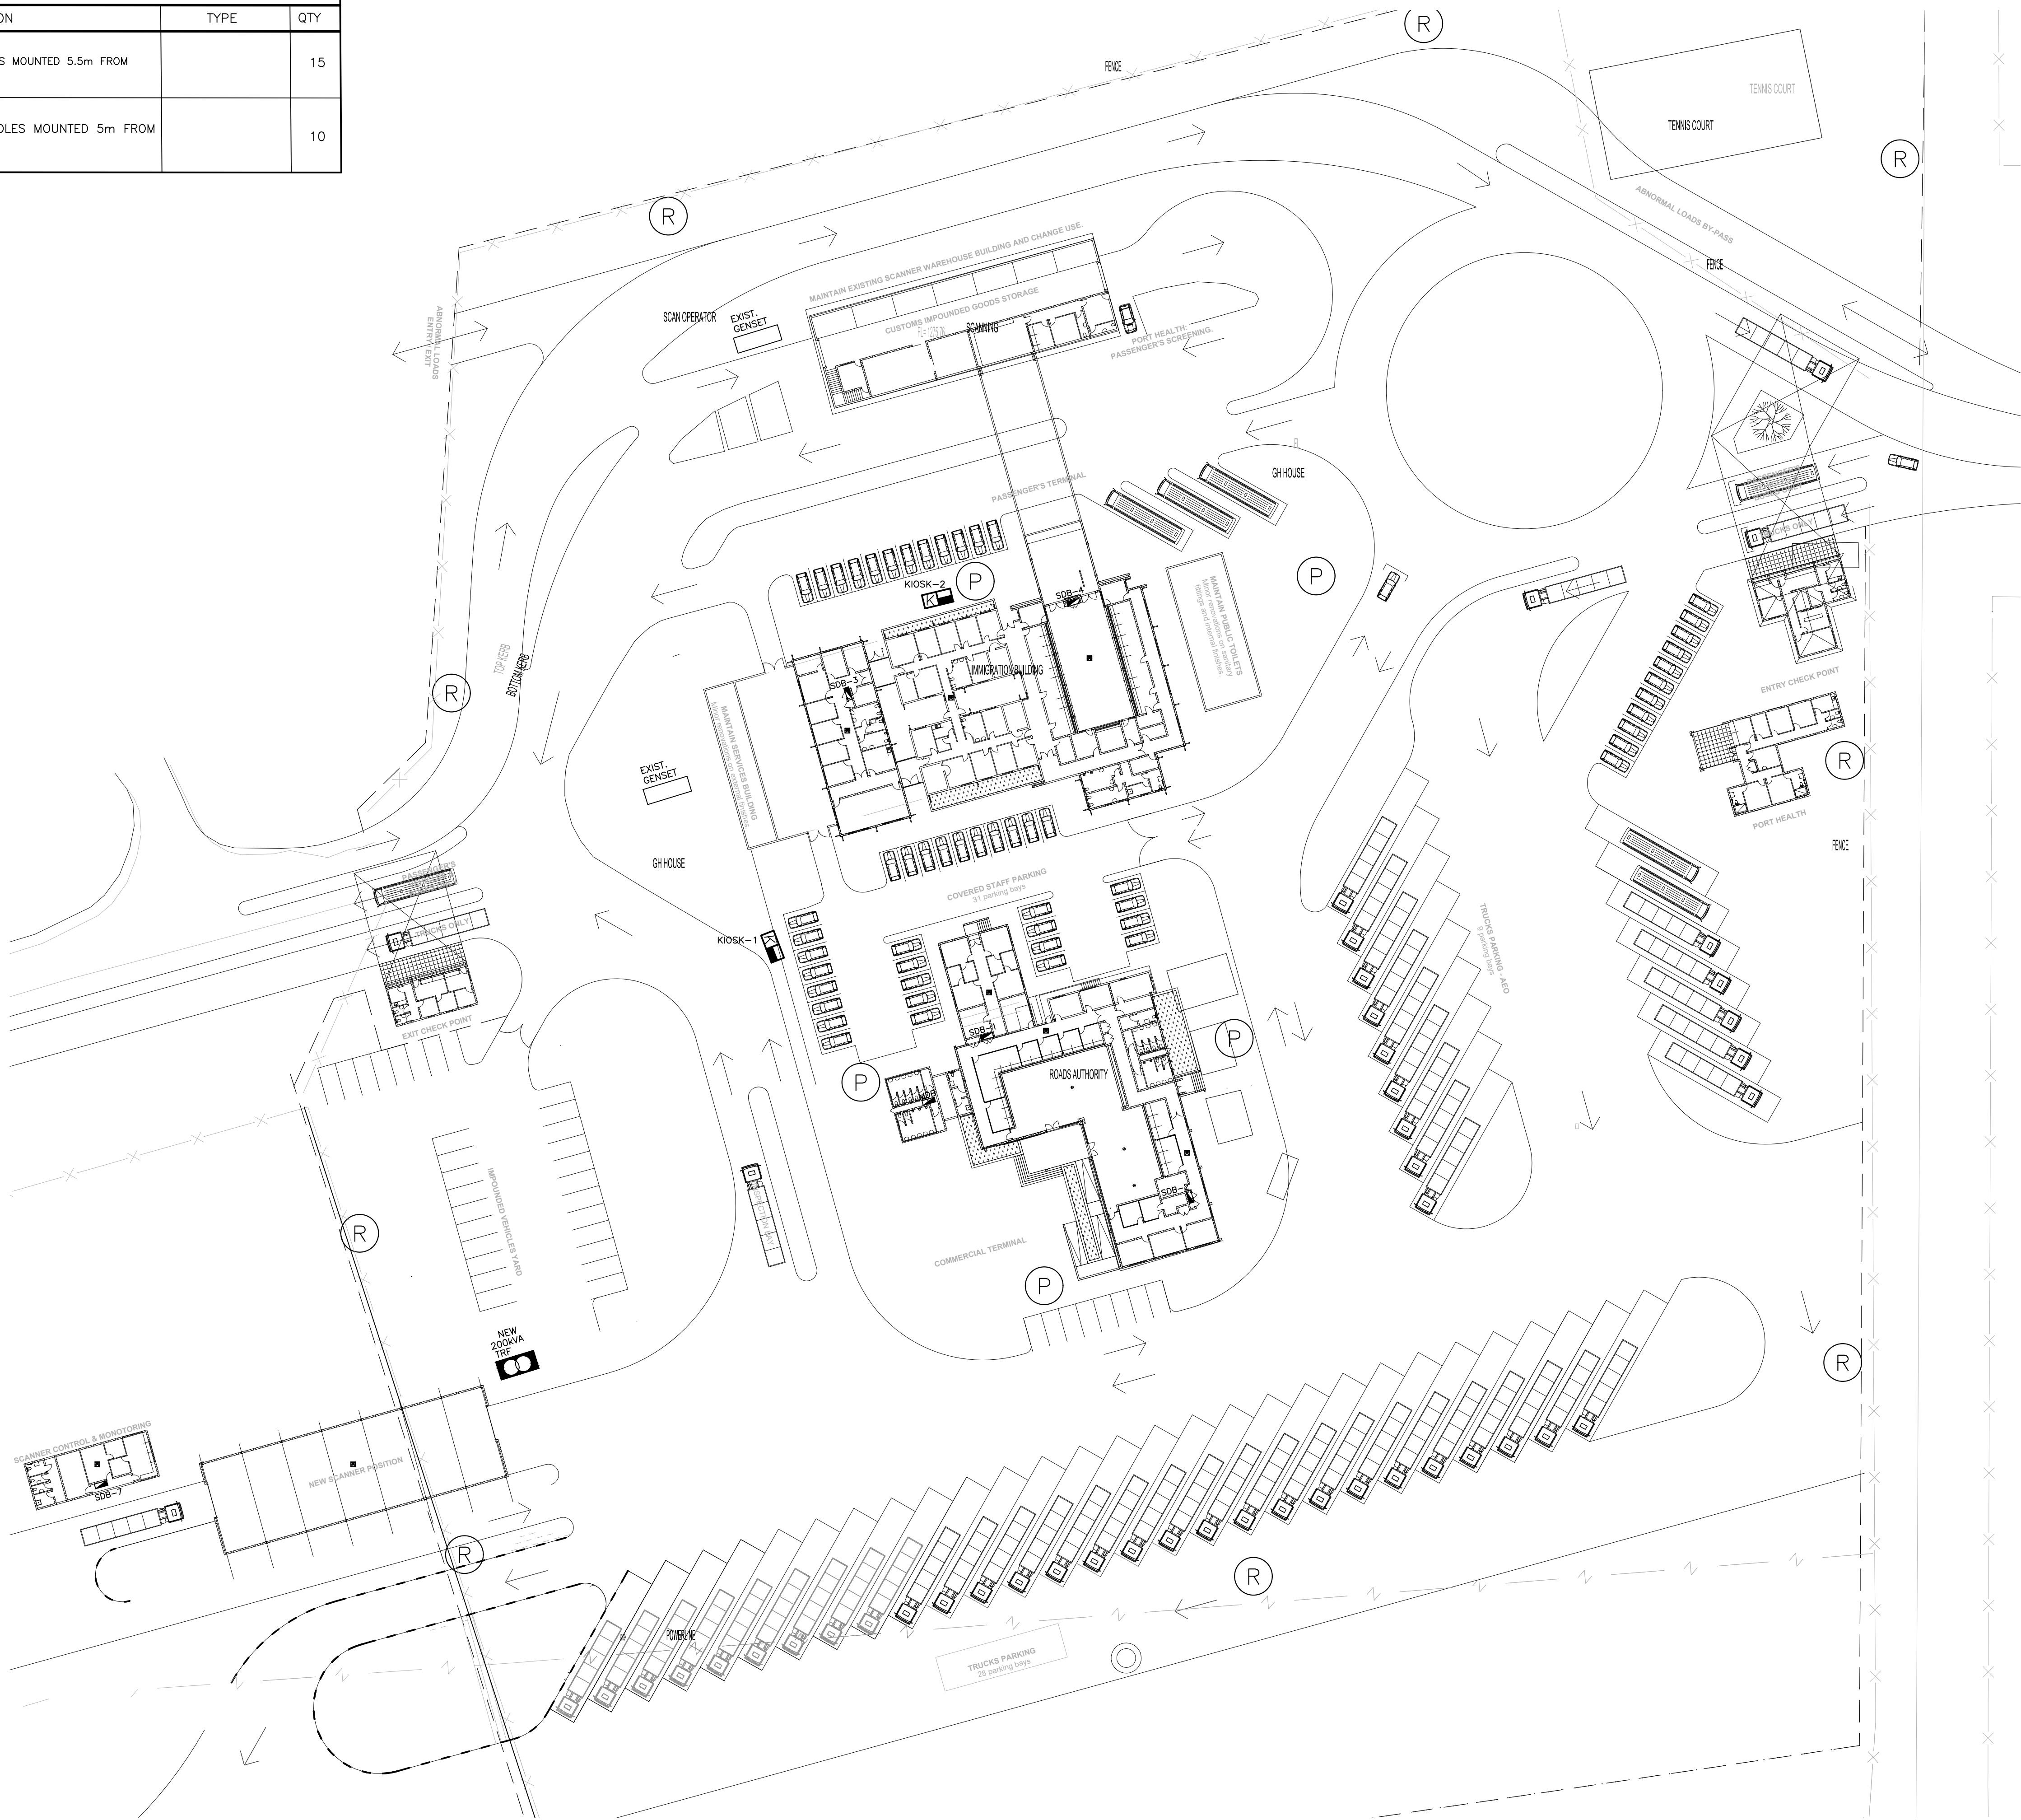

NOTES

1. THIS DRAWING SHOULD BE READ IN CONJUNCTION WITH THE RELEVANT ARCHITECTURAL, MECHANICAL & ELECTRICAL DRAWINGS.

2. INSTALLATION SHALL BE ACCORDING WITH RELEVANT SABS SPECIFICATIONS AND IN PARTICULAR SANS 10142-1, THE WIRING OF PREMISES.

3. SYMBOLS ON THIS DRAWING ARE NOT A TRUE REFLECTION OF SIZE OF ITEM/EQUIPMENT INTENDED, BUT MERELY A GRAPHICAL PRESENTATION.

FOR BIDDING PURPOSES ONLY

No.	REVISIONS			ENG.	DATE			
ARCHITECT								
			P.O. Box 11257 WINDHOEK, NAMIBIA TEL: (061) 259 125 kuda@chigamaarch.com					
QUANTITY SURVEYOR								
			P.O. Box 90680 WINDHOEK, NAMIBIA TEL: (061) 220 081 info@jonges.com					
CIVIL & STRUCTURAL ENGINEERS								
			P.O. Box 21744 Tel: 061 220 959 Fax: 061 220 992 E-mail: info@dekaconsult.com WINDHOEK					
ELEC & MECH. ENGINEERS:								
			P.O. Box 21744 Tel: 061 220 959 Fax: 061 220 992 E-mail: info@dekaconsult.com WINDHOEK					
DESIGN								
DESIGNED	RJ	01/24	DRAWN	HFM	01/24			
PROFESSIONAL ENGINEER			ADJ					
CLIENT:								
NAMIBIA REVENUE AGENCY 10 JOHN MEINERT & MOKTJE STREET, WINDHOEK TEL: (061) 209 2259								
DISCIPLINE: ELECTRICAL								
PROJECT TITLE: REFURBISHMENT OF TRANS KALAHARI BORDER TO A ONE STOP BORDER POST								
DRAWING TITLE: SITE PLAN AREA LIGHTING LAYOUT								
SCALE: 1 : 500					A1			
CONSULTANT DRAWING NO.: D0121/E1-010					REV. 			
CLIENT DRAWING NO.:					REV. 			