


SYMBOL LIST				
No	SYMBOL	DESCRIPTION	TYPE	QTY
1		16A SWITCHED TWIN SOCKET-OUTLET WITH SAFETY SHUTTERS 250V. 2P + EARTH WITH SIDE CONTACTS. FLUSH MOUNTED @ 300mm AFFL.	CLIPSAL S2000 OR EQUAL	6
2		16A SWITCHED TWIN SOCKET-OUTLET WITH SAFETY SHUTTERS 250V. 2P + EARTH WITH SIDE CONTACTS. FLUSH MOUNTED @ 1200mm AFFL.	CLIPSAL S2000 OR EQUAL	2
3		RSA STANDARD 16A TWIN SOCKET-OUTLET WITH SAFETY SHUTTERS 250V. 2P+EARTH WITH SIDE CONTACTS. FLUSH MOUNTED ON POWER SKIRTING.	CLIPSAL S2000 OR EQUAL	-
4		OUTLET CLUSTER TYPE A MOUNTED ON POWER SKIRTING WITH 2x RSA STANDARD 16A SOCKET-OUTLET + 1x RJ45 DATA/COMPUTER NETWORK POINT, SHIELDED. SUITABLE FOR CATEGORY 6, FOR 10/250MB FAST ETHERNET NETWORKS + 1x RJ45 TELEPHONE SOCKET + 1x RSA STANDARD 16A SWITCHED DEDICATED SOCKET OUTLET. POWER SKIRTING WITH SAFETY SHUTTERS 250V.	CABSTRUT CLASSIC GC/2 OR EQUAL	54
5		ROUND BOX FOR AC CONTROLLER		-
6		INTERCOM. MAKE PROVISION FOR INTERCONNECTING INTERCOM CABLE WIRE WAY AND 60mm ROUND BOX AT 2300AFFL. ALL BUILDINGS TO CONNECT BACK TO ADMIN HEADMASTER OFFICE VIA 32mm SLEEVE		-
7		MULTI COMPARTMENT FLEXIBLE POWER SKIRTING MOUNTED AT FFL. COMPLETE WITH SNAP-ON COVERS, ELBOWS, END CAPS etc. DIMS. OF AT LEAST 150mm x 50mm.	CABSTRUT CLASSIC GC/2 OR EQUAL	95m
8		ROTARY WALL-MOUNTING ISOLATOR SWITCH WITH RED PADLOCKABLE KNOB ON YELLOW FLANGE. DP 16A, 32A OR 63A. IP-65. RATING AS SHOWN	GEWISS GW 70431/4/7 OR SIMILAR APPROVED	-
9		ROTARY WALL-MOUNTING ISOLATOR SWITCH WITH RED PADLOCKABLE KNOB ON YELLOW FLANGE. TP 16A, 20A, 32A OR 63A. IP-65.	GEWISS GW 70431/4/7 OR SIMILAR APPROVED	4
10		EPOXY COATED, SHEETMETAL POWER DISTRIBUTION ENCLOSURE. FLUSH MOUNTED @1400mm AFFL.	GEM OR SIMILAR APPROVED	2
11		RECESSED FLOOR OF DESK SOCKET OUTLET CLUSTER WITH 2x RSA STANDARD 16A SOCKET-OUTLET + 1xRJ45 DATA/COMPUTER NETWORK POINT, SHIELDED. SUITABLE FOR CATEGORY 6A, FOR 10/100MB FAST ETHERNET NETWORKS + 1xRJ45 TELEPHONE SOCKET + 1X RSA STANDARD 16A SWITCHED DEDICATED SOCKET OUTLET. WITH SAFETY SHUTTERS 250V.	CABSTRUT CLASSIC GC/2 OR EQUAL	1

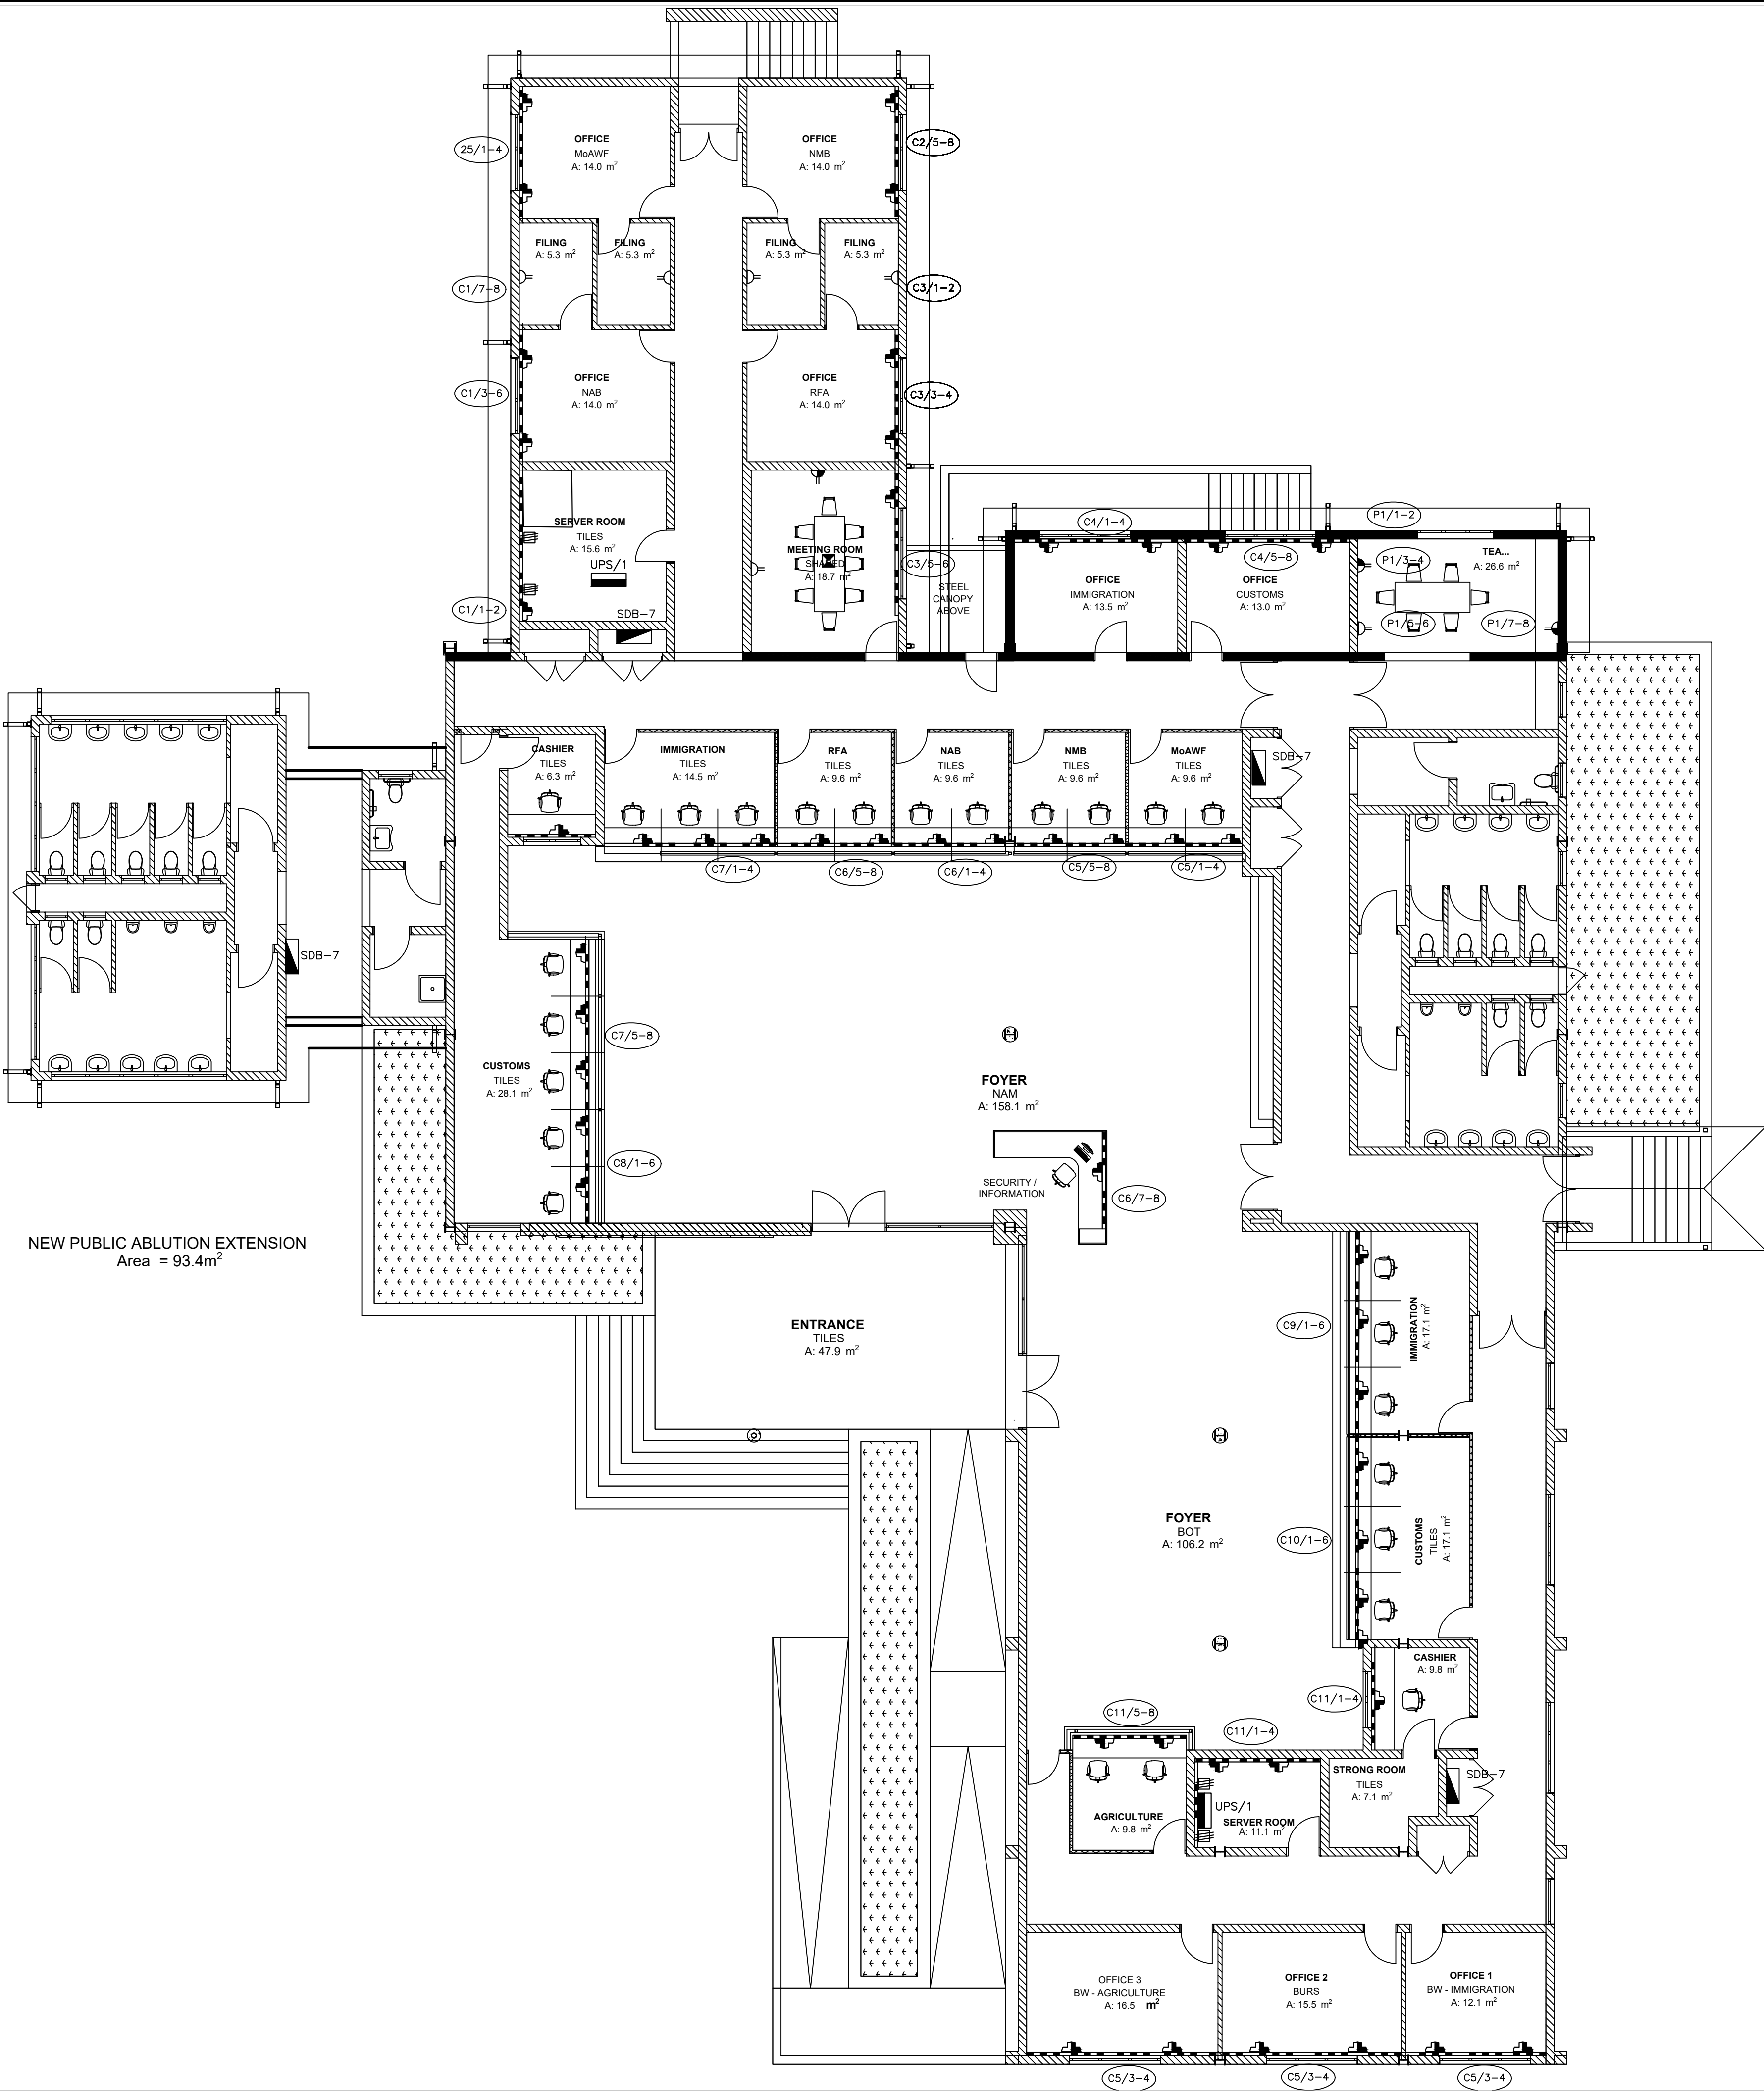

NOTES			
FOR BIDDING PURPOSES ONLY			
No.	REVISIONS	ENG.	DATE
ARCHITECT			
		P.O. Box 11257 WINDHOEK, NAMIBIA TEL: (061) 259 125 kuda@chigamaarch.com	
QUANTITY SURVEYOR			
		P.O. Box 90680 WINDHOEK, NAMIBIA TEL: (061) 220 081 info@jongqs.com	
CIVIL & STRUCTURAL ENGINEERS			
		P.O. Box 21744 Tel: 061 220 959 Fax: 061 220 992 E-mail: info@dekaconsult.com	
ELEC & MECH. ENGINEERS:			
		P.O. Box 21744 Tel: 061 220 959 Fax: 061 220 992 E-mail: info@dekaconsult.com WINDHOEK	
DESIGN			
DESIGNED	RJ	01/24	DRAWN RJ 01/24
PROFESSIONAL ENGINEER		ADJ	
CLIENT:			
			
NAMIBIA REVENUE AGENCY 10 JOHN MEINERT & MOLKTE STREET, WINDHOEK TEL: (061) 209 2259			
DISCIPLINE: ELECTRICAL			
PROJECT TITLE: REFURBISHMENT OF TRANS KALAHARI BORDER TO A ONE STOP BORDER POST			
DRAWING TITLE: COMMERCIAL TERMINAL : SMALL POWER LAYOUT			
SCALE: 1 : 100			A1
CONSULTANT DRAWING NO.: D0121/E1-101			REV. 
CLIENT DRAWING NO.:			REV. 

STOREROOM
NamRA
A: 8.6 m²

CONTROL ROOM
NamRA
A: 2.0 m²

SERVER
NamRA
A: 11.2 m²

UPS/1

OFFICE 1
NamRA
A: 16.0 m²

OFFICE 2
NAMRA
A: 12.0 m²

OFFICE 3
NAMRA
A: 12.0 m²

OFFICE 4
NAMRA
A: 12.0 m²

OFFICE 5
NAMRA
A: 12.0 m²

FILING
NamRA
A: 8.6 m²

TEA ROOM
SHARED
A: 14.9 m²


CIRCULATION AREA
TILES
A: 54.8 m²

MEETING ROOM
SHARED
A: 51.1 m²

STEEL CANOPY ABOVE

STEEL CANOPY ABOVE

Parking area for projector in ceiling void


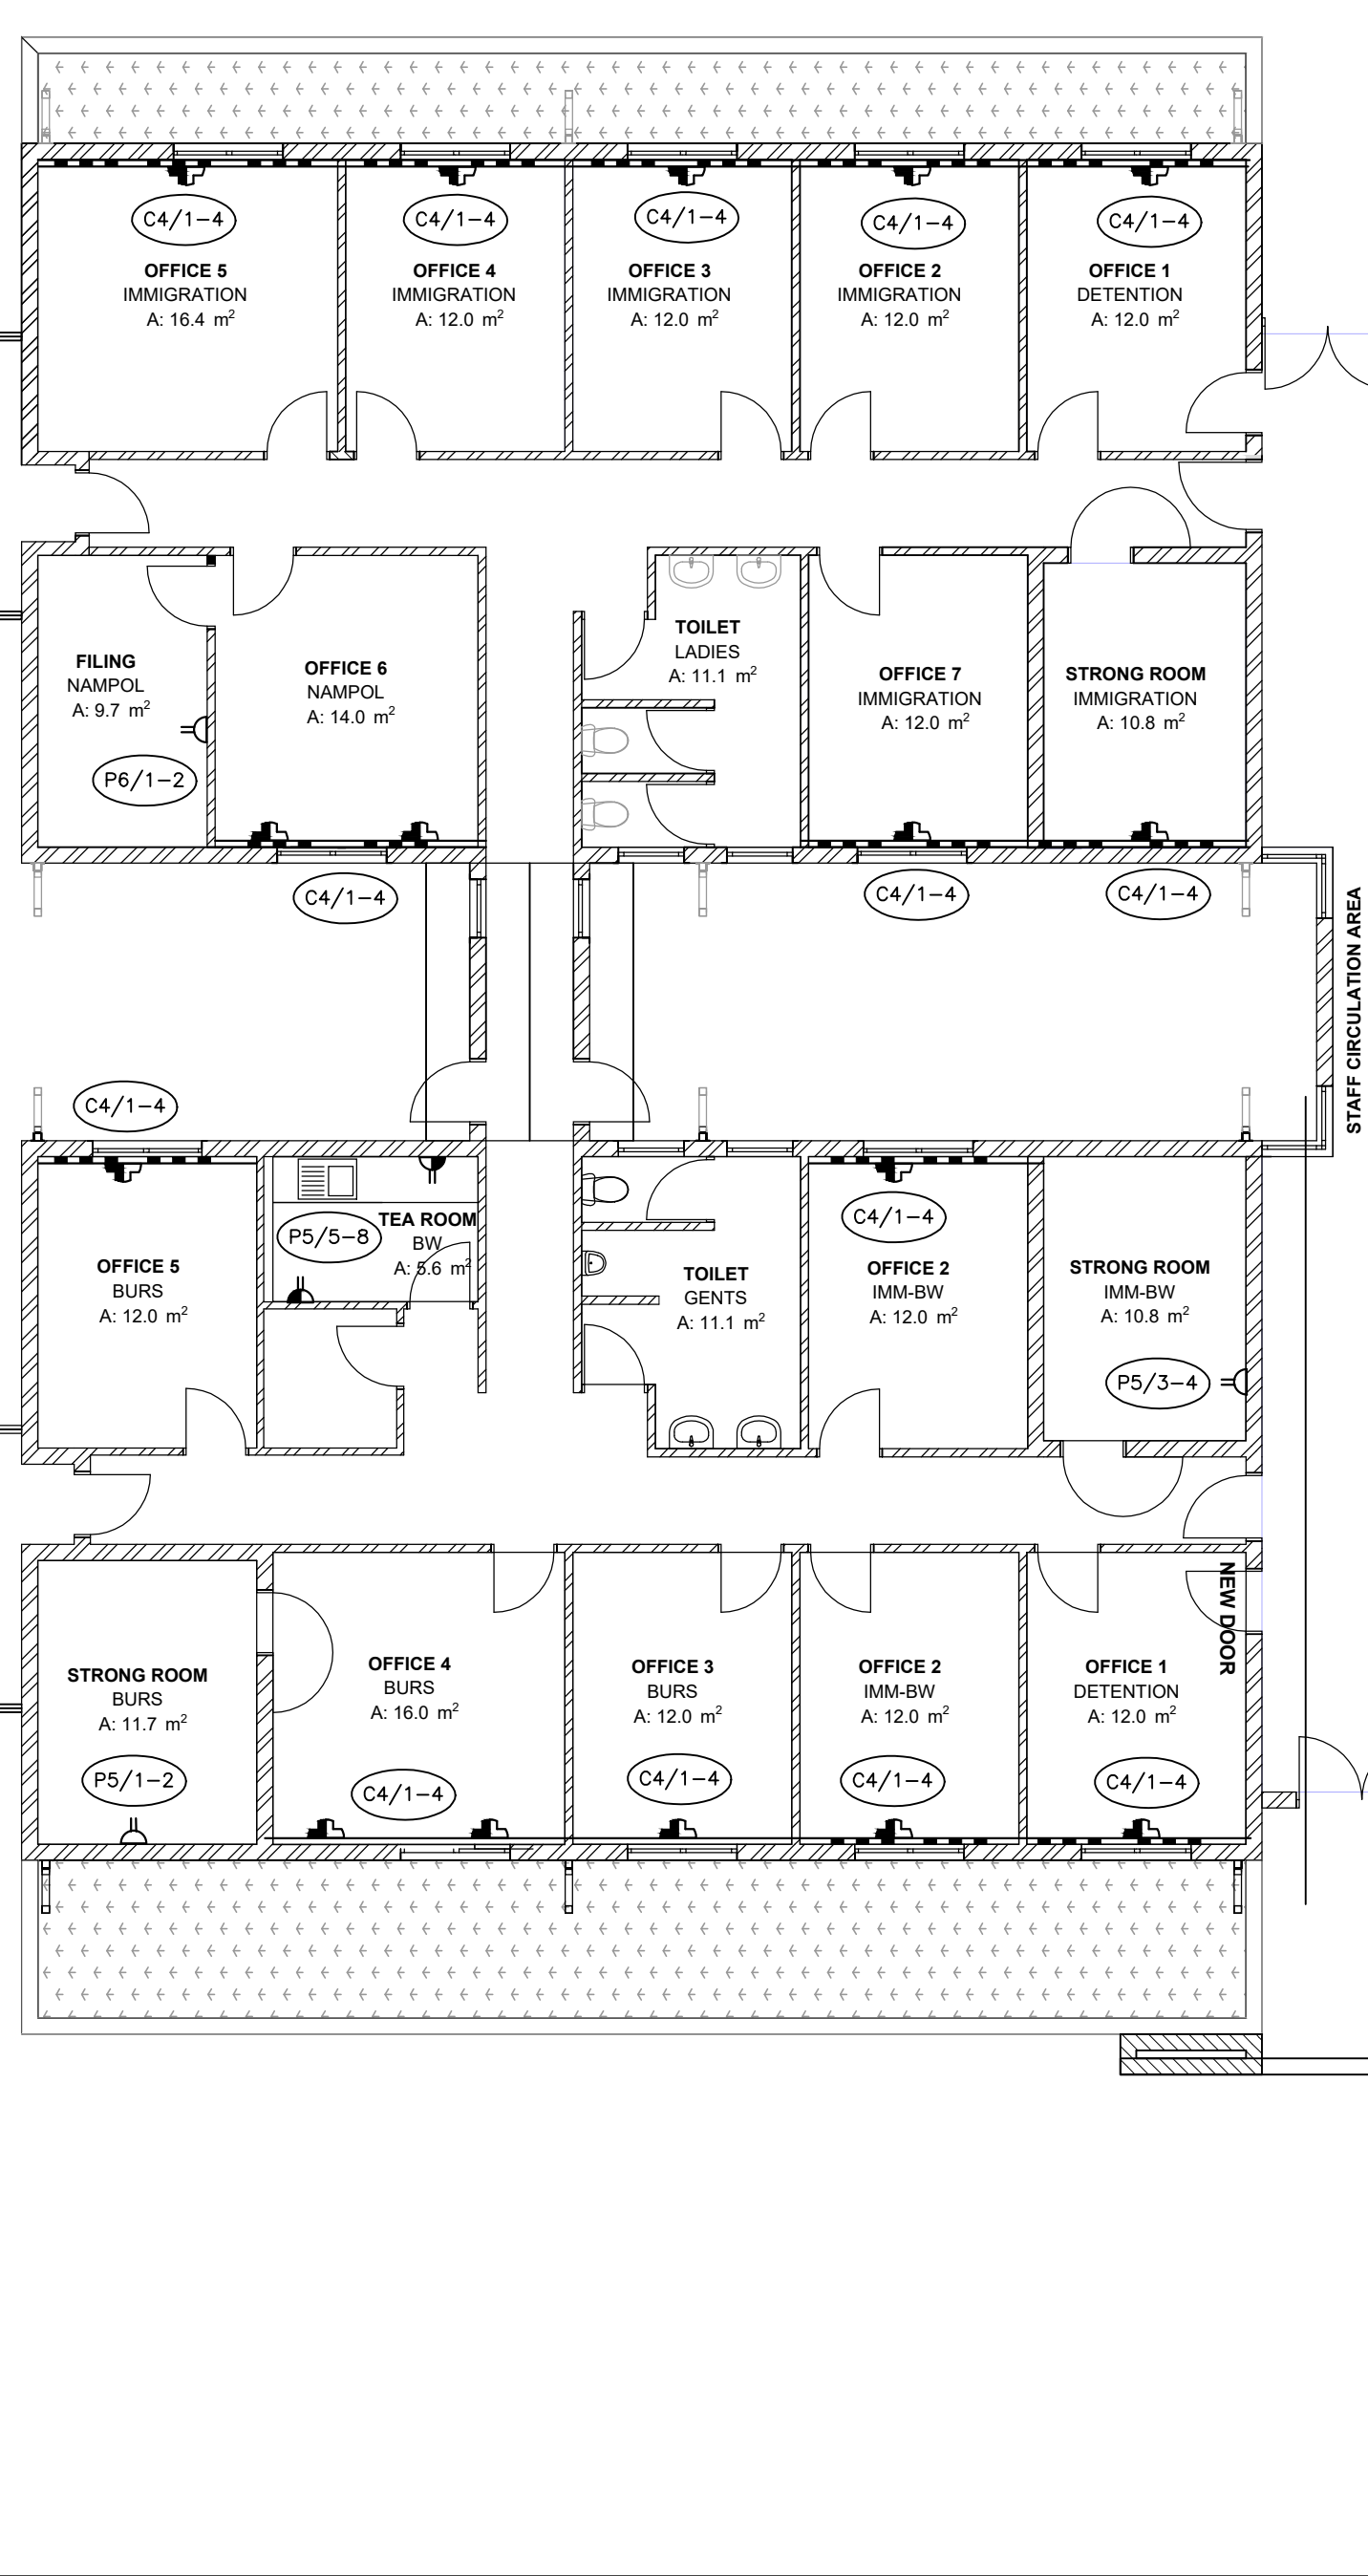



ARCHITECT Chigama Architects		P.O. Box 11257 WINDHOEK, NAMIBIA TEL: (061) 259 125 kuda@chigamaarch.com	
QUANTITY SURVEYOR			
 Jonathan Oshagorongo Namgila Quantity Surveyor 10000 Windhoek, Namibia www.Oshagorongo.com		P.O. Box 90680 WINDHOEK, NAMIBIA TEL: (061) 220 081 info@jongsqs.com	
CIVIL & STRUCTURAL ENGINEERS			
 DEKA CONSULTING ENGINEERS		P. Box 21342/1744 081: 200 2029 959 F: 061: 200 2029 992 m.b.mfira@dekaconsultants.com NDHNDHEOKE	
ELEC. & MECH. ENGINEERS:			
 DEKA CONSULTING ENGINEERS		P. Box 21342/1744 081: 200 2029 959 F: 061: 200 2029 992 m.b.mfira@dekaconsultants.com NDHNDHEOKE	
DESIGN			
DESIGNED	RJ	01/24	DRAWN
PROFESSIONAL ENGINEER		ADJ	RJ
01/24		01/24	
CLIENT:			
 NAMIBIA REVENUE AGENCY 10 JOHN MEINERT & MOLKTE STREET, WINDHOEK TEL: (061) 209 2259			
DISCIPLINE: ELECTRICAL			
PROJECT TITLE:			
REFURBISHMENT OF TRANS KALAHARI BORDER TO A ONE STOP BORDER POST			
DRAWING TITLE:			
COMMERCIAL TERMINAL : SMALL POWER LAYOUT			
SCALE:			A1
1 : 100			REV.
CONSTRUCT DRAWING NO.:			REV.
D0121/E1-101			
CLIENT DRAWING NO.:			

The floor plan illustrates the layout of the 1st floor, featuring a central corridor system connecting various functional areas. Key rooms include:

- Staff Toilets:** Located on the left, with an area of 65.9 m².
- New Public Ablution Extension:** A large area on the left, totaling 93.4 m².
- Entrance:** A large central area with a tiled floor, measuring 47.9 m².
- Foyer (Top):** A large open space at the top, measuring 158.1 m².
- Foyer (Bottom):** A large open space at the bottom, measuring 106.2 m².
- Offices:** Multiple offices are distributed throughout, including:
 - Office MoAWF (14.0 m²), Office NMB (14.0 m²), Office NAB (14.0 m²), Office RFA (14.0 m²), Office Immigration (13.5 m²), Office Customs (13.0 m²), Office 3 Burs (16.5 m²), Office 2 Burs (15.5 m²), and Office 1 BW - Immigration (12.1 m²).
- Service Areas:**
 - Meeting Room:** A central room with a table and chairs, measuring 18.7 m².
 - Server Room:** Located near the center, measuring 15.6 m².
 - Strong Room:** A secure storage area, measuring 7.1 m².
 - Agiculture:** A room at the bottom, measuring 9.8 m².
 - Tea Room:** A room at the top right, measuring 26.6 m².
- Checkpoints and Tiled Areas:**
 - Cashier:** A service counter, measuring 6.3 m².
 - Immigration Tiles:** A large area for immigration processing, measuring 14.5 m².
 - RFA Tiles:** A tiled area for RFA, measuring 9.6 m².
 - NAB Tiles:** A tiled area for NAB, measuring 9.6 m².
 - NMB Tiles:** A tiled area for NMB, measuring 9.6 m².
 - MoAWF Tiles:** A tiled area for MoAWF, measuring 9.6 m².
 - Customs Tiles:** A tiled area for customs, measuring 28.1 m².
 - Immigration Tiles:** A tiled area for immigration, measuring 11.1 m².
 - Customs Tiles:** A tiled area for customs, measuring 11.1 m².
 - Cashier Tiles:** A tiled area for the cashier, measuring 9.8 m².
- Other Features:**
 - Security / Information:** A small room near the top foyer.
 - Steel Canopy Above:** A designated area for a steel canopy.
 - IR-1 through IR-15:** Various rooms and corridors labeled with IR numbers.
 - SDB-7:** Several small rooms labeled SDB-7.

NOTES				
1. THIS DRAWING SHOULD BE USED IN CONJUNCTION WITH THE RELEVANT ARCHITECTURAL, MECHANICAL & ELECTRICAL DRAWINGS.				
2. INSTALLATION SHALL BE ACCORDING WITH RELEVANT SABS SPECIFICATIONS AND IN PARTICULAR SANS 10142-1, THE WIRING OF PREMISES.				
3. SYMBOLS ON THIS DRAWING ARE NOT A TRUE REFLECTION OF SIZE OF ITEM/EQUIPMENT INTENDED, BUT MERELY A GRAPHICAL PRESENTATION.				
FOR BIDDING PURPOSES ONLY				
No.	REVISIONS	ENG.	DATE	
ARCHITECT				
		P.O. Box 11257 WINDHOEK, NAMIBIA TEL: (061) 259 125 kuda@chigamaarch.com		
QUANTITY SURVEYOR				
		P.O. Box 90690 WINDHOEK, NAMIBIA TEL: (061) 220 081 info@jonggus.com		
CIVIL & STRUCTURAL ENGINEERS				
		P.O. Box 21744 Tel: 061 220 959 Fax: 061 220 992 E-mail: info@dekaconsult.com WINDHOEK		
ELECT & MECH. ENGINEERS:				
		P.O. Box 21744 Tel: 061 220 959 Fax: 061 220 992 E-mail: info@dekaconsult.com WINDHOEK		
DESIGN				
DESIGNED	RJ	01/24	DRAWN	HFM
PROFESSIONAL ENGINEER		AdJ		01/24
CLIENT:				
NAMIBIA REVENUE AGENCY 10 JOHN MEINERT & MOLKTE STREET, WINDHOEK TEL: (061) 209 2259				
DISCIPLINE: ELECTRICAL				
PROJECT TITLE:				
REFURBISHMENT OF TRANS KALAHARI BORDER TO A ONE STOP BORDER POST				
DRAWING TITLE:				
COMMERCIAL TERMINAL : ACCESS CONTROL AND INTRUSION DETECTION LAYOUT				
SCALE: 1 : 100				A1
CONSULTANT DRAWING NO.: D0121/E3-300				
CLIENT DRAWING NO.:				

  
SYMBOL LIST		
SYMBOL	DESCRIPTION	QTY
	CCTV DISTRIBUTION BOARD 1500mm ABOVE FLOOR LEVEL	1
	180° IP CAMERAS	13
	360° IP CAMERAS	—
	CCTV CABLING	500m
	OUTDOOR CAMERAS, BULLET POINT, WITH HIGH RANGE VIEW AND IP65 RATED	11

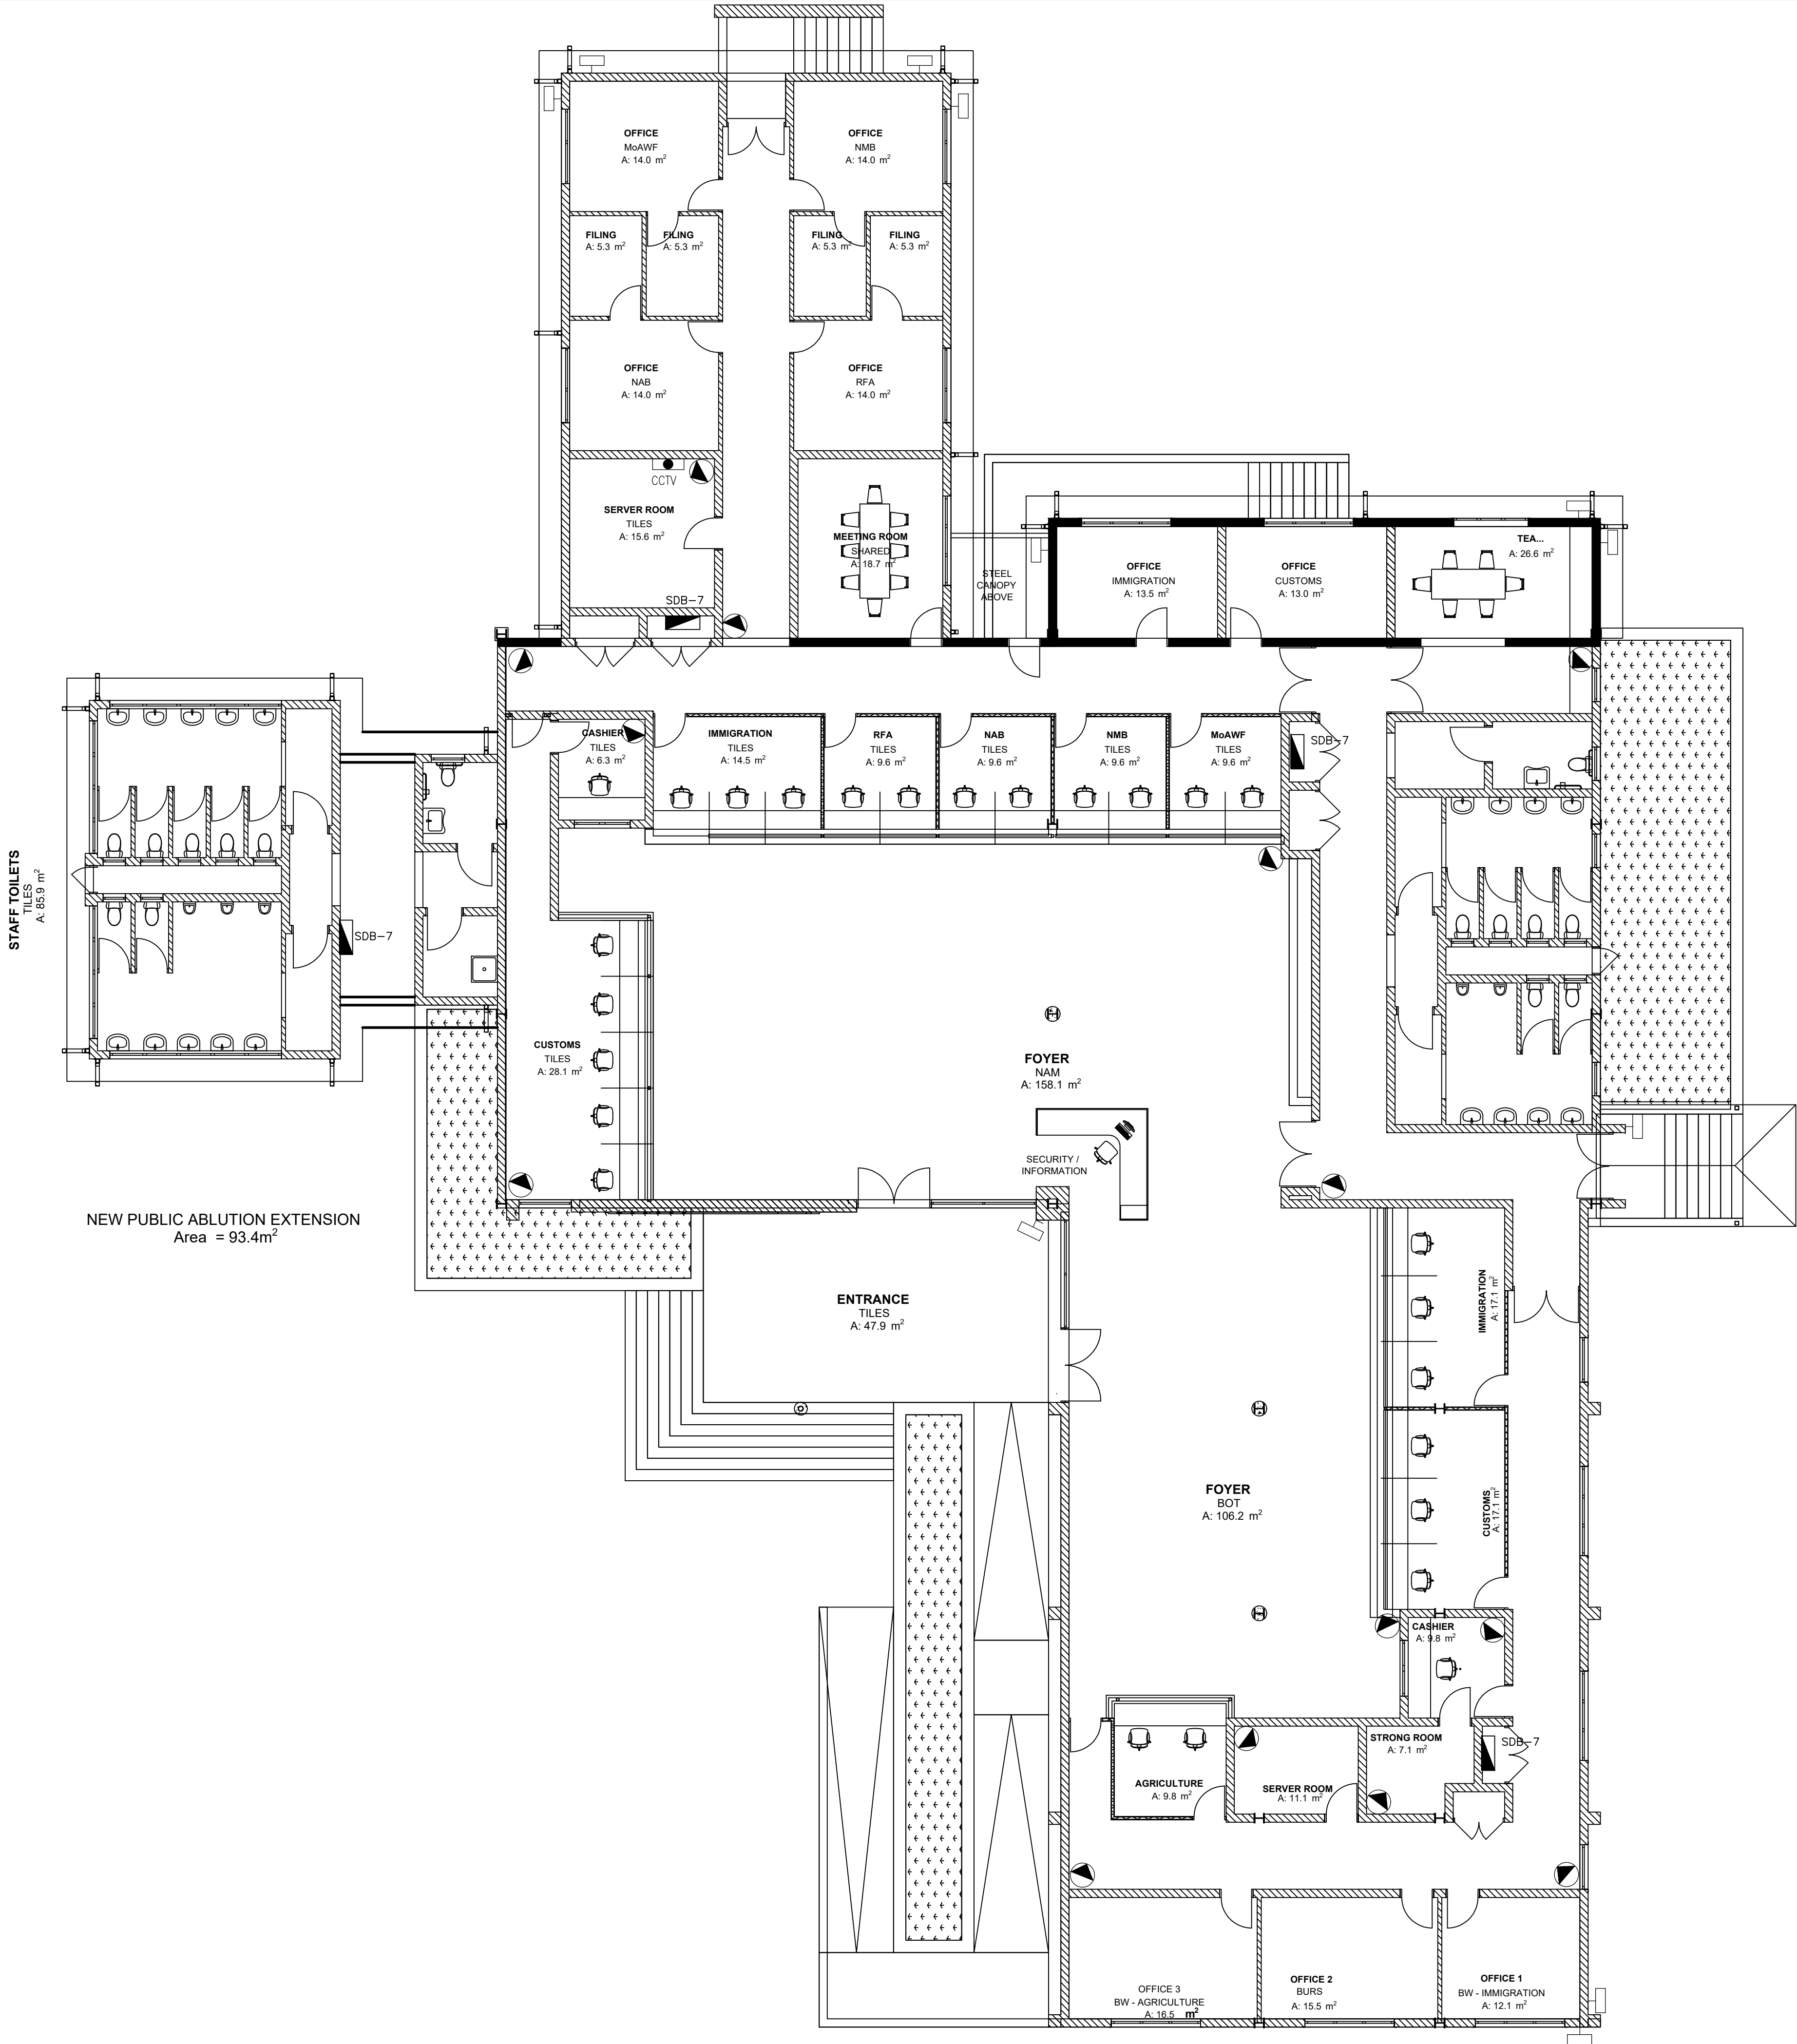


NOTES		
1. THIS DRAWING SHOULD BE READ IN CONJUNCTION WITH THE RELEVANT ARCHITECTURAL, MECHANICAL & ELECTRICAL DRAWINGS.		
2. INSTALLATION SHALL BE ACCORDING WITH RELEVANT SABS SPECIFICATIONS AND IN PARTICULAR SANS 10142-1, THE WIRING OF PREMISES.		
3. SYMBOLS ON THIS DRAWING ARE NOT A TRUE REFLECTION OF SIZE OF ITEM/EQUIPMENT INTENDED, BUT MERELY A GRAPHICAL PRESENTATION.		
FOR BIDDING PURPOSES ONLY		
No.	REVISIONS	ENG. DATE
ARCHITECT		
		P.O. Box 11257 WINDHOEK, NAMIBIA TEL: (061) 259 125 kuda@chigamaarch.com
QUANTITY SURVEYOR		
		P.O. Box 90680 WINDHOEK, NAMIBIA TEL: (061) 220 081 info@jongqs.com
CIVIL & STRUCTURAL ENGINEERS		
		P.O. Box 21744 Tel: 061 220 959 Fax: 061 220 992 E-mail: info@dekaconsult.com WINDHOEK
ELEC & MECH. ENGINEERS:		
		P.O. Box 21744 Tel: 061 220 959 Fax: 061 220 992 E-mail: info@dekaconsult.com WINDHOEK
DESIGN		
DESIGNED	RJ	01/24
DRAWN	HFM	01/24
PROFESSIONAL ENGINEER		Adj
CLIENT:		
		
NAMIBIA REVENUE AGENCY 10 JOHN MEINERT & MOLKE STREET, WINDHOEK TEL: (061) 209 2259		
DISCIPLINE: ELECTRICAL		
PROJECT TITLE:		
REFURBISHMENT OF TRANS KALAHARI BORDER TO A ONE STOP BORDER POST		
DRAWING TITLE:		
COMMERCIAL TERMINAL : CCTV LAYOUT		
SCALE: 1 : 100		A1
CONSULTANT DRAWING NO.: D0121/E3-301		REV.
CLIENT DRAWING NO.:		REV.

[illegible][illegible]

SYMBOL LIST		
SYMBOL	DESCRIPTION	QTY
	CCTV DISTRIBUTION BOARD 1500mm ABOVE FLOOR LEVEL	1
	OUTDOOR CAMERAS, BULLET POINT, WITH HIGH RANGE VIEW AND IP65 RATED	20
	CCTV CABLING	1800m

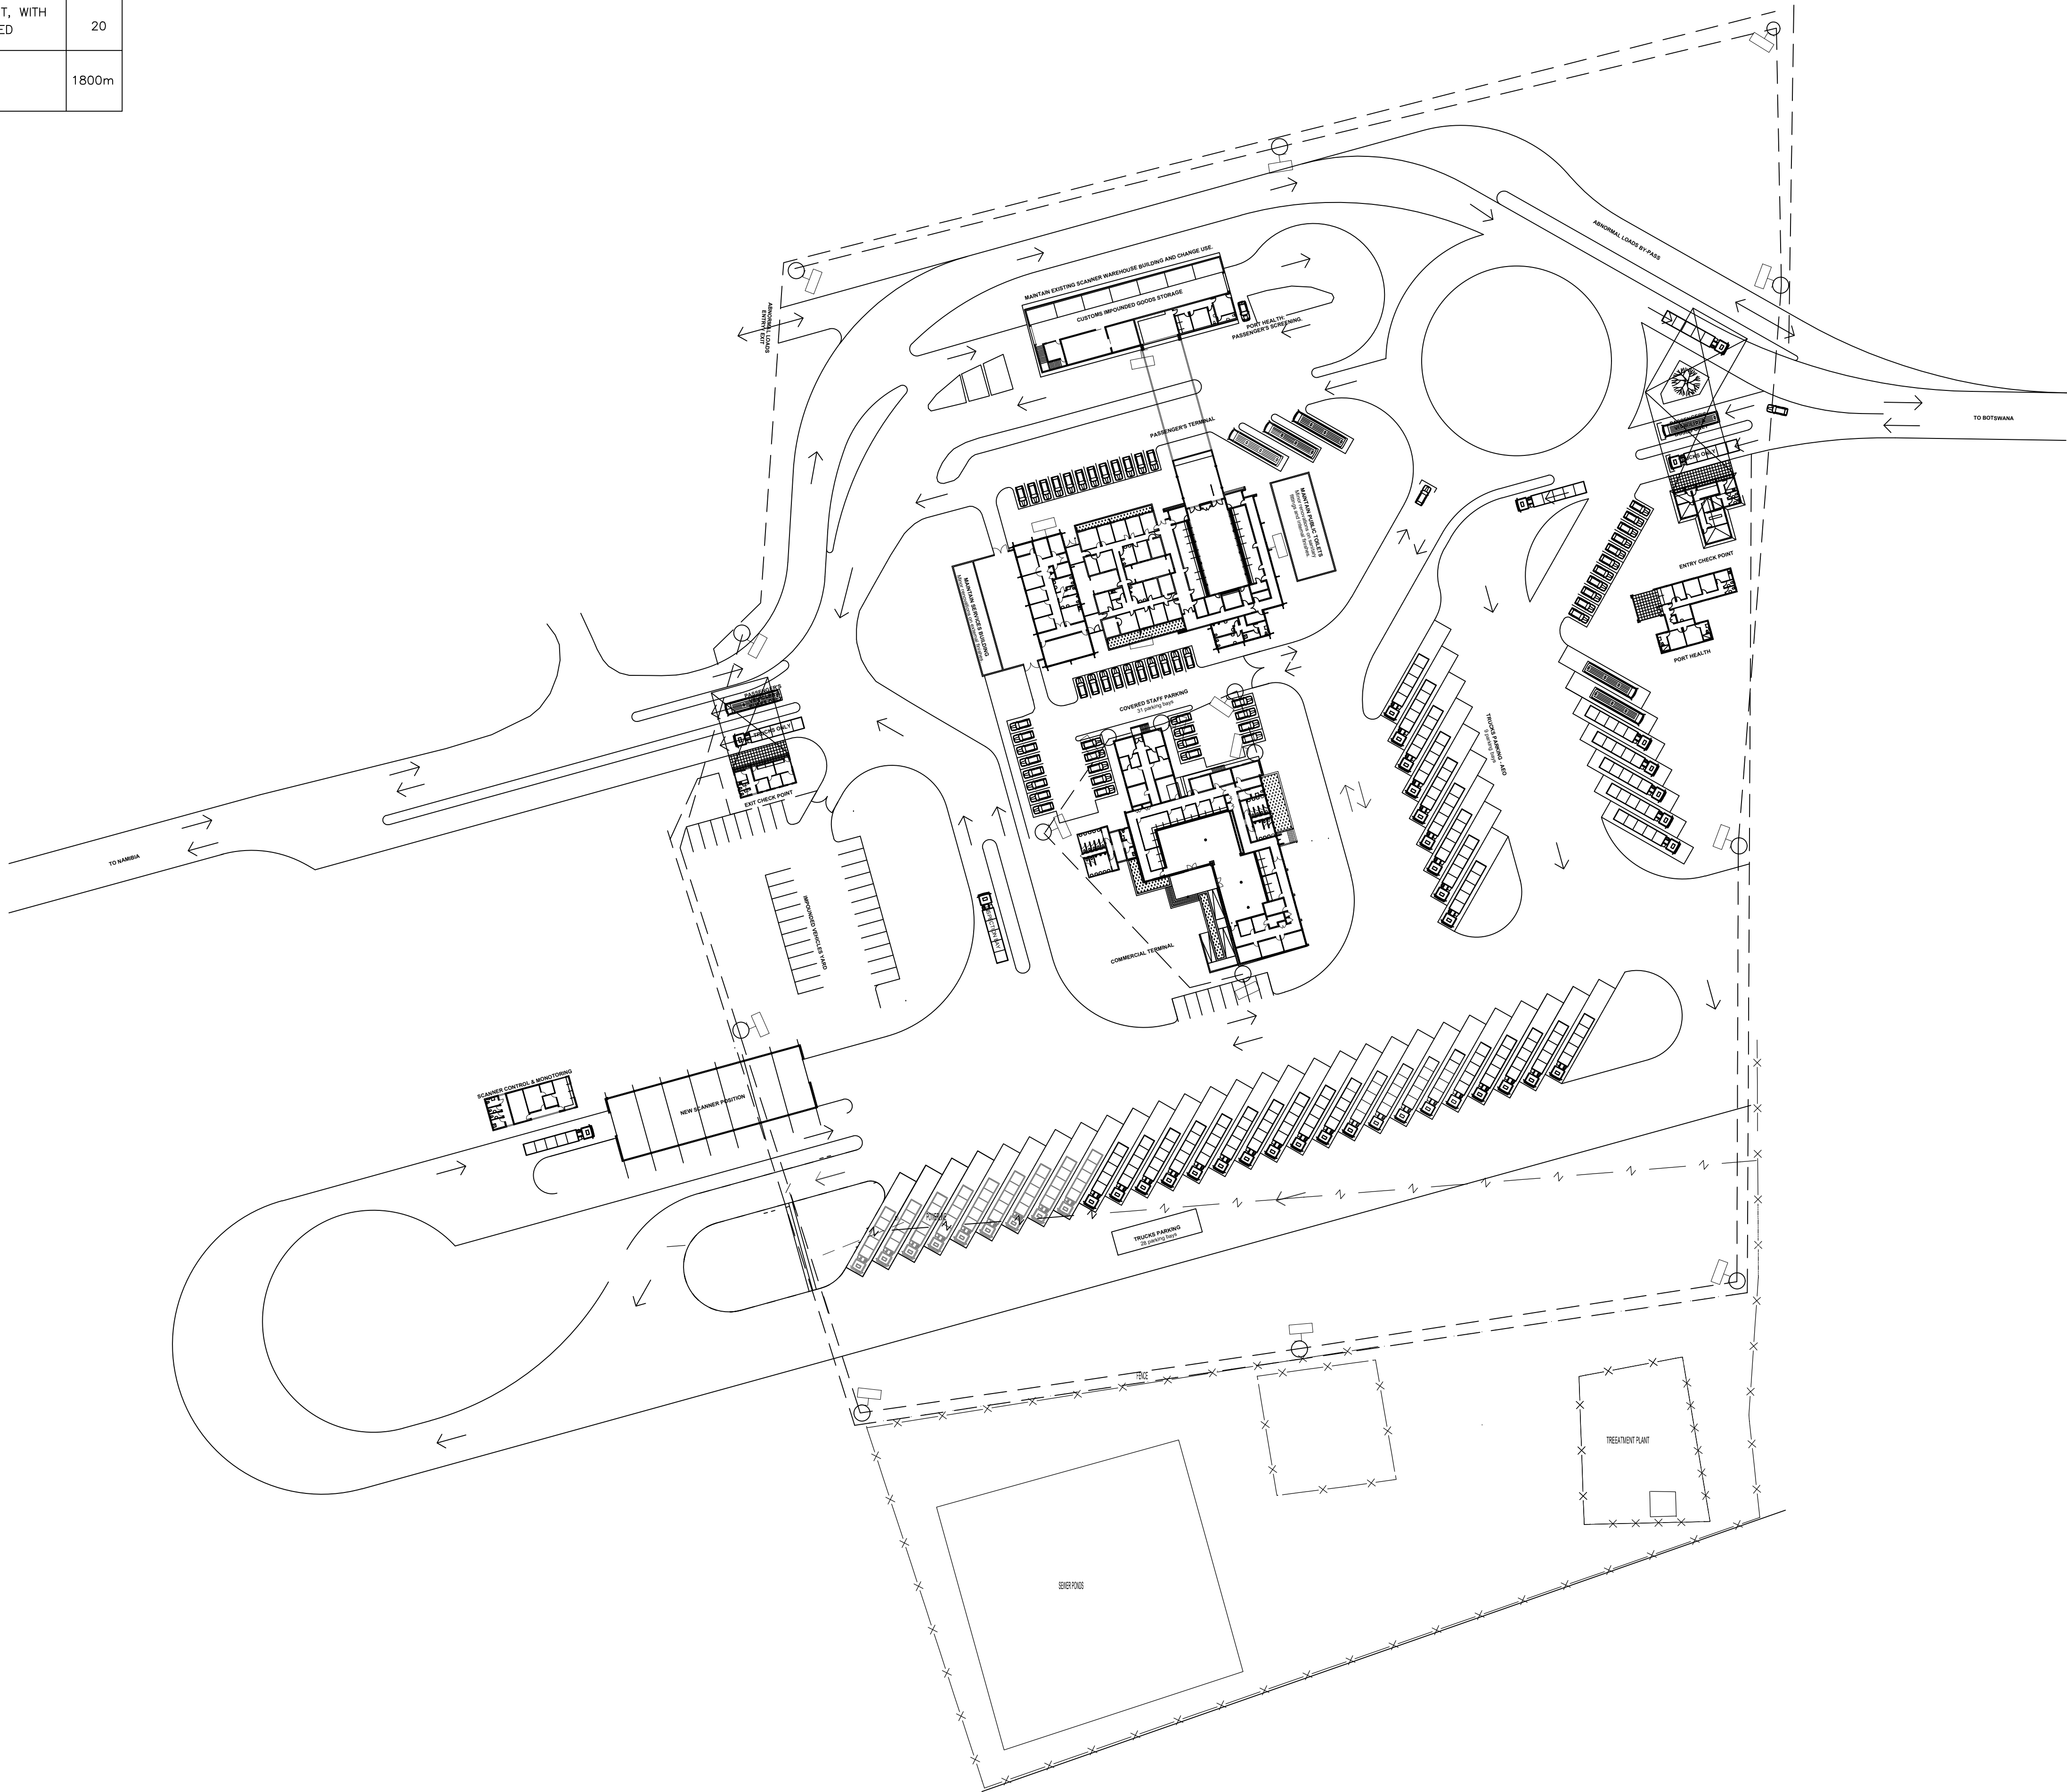

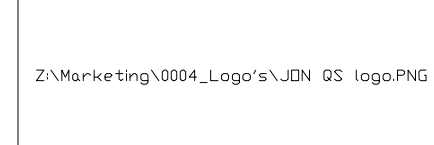NOTES			
FOR BIDDING PURPOSES ONLY			
No.	REVISIONS	ENG.	DATE
ARCHITECT			
		P.O. Box 11257 WINDHOEK, NAMIBIA TEL: (061) 259 125 kuda@chigamaarch.com	
QUANTITY SURVEYOR			
		P.O. Box 90680 WINDHOEK, NAMIBIA TEL: (061) 220 081 info@jonggs.com	
CIVIL & STRUCTURAL ENGINEERS			
		P.O. Box 21744 Tel: 061 220 959 Fax: 061 220 992 E-mail: info@dekaconsult.com WINDHOEK	
ELEC & MECH. ENGINEERS:			
		P.O. Box 21744 Tel: 061 220 959 Fax: 061 220 992 E-mail: info@dekaconsult.com WINDHOEK	
DESIGN			
DESIGNED	RJ	01/24	DRAWN HFM 01/24
PROFESSIONAL ENGINEER		Adj	
CLIENT:			
			
NAMIBIA REVENUE AGENCY 10 JOHN MEINERT & MOKETE STREET, WINDHOEK TEL: (061) 209 2259			
DISCIPLINE:		ELECTRICAL	
PROJECT TITLE:			
REFURBISHMENT OF TRANS KALAHARI BORDER TO A ONE STOP BORDER POST			
DRAWING TITLE:			
SITE PLAN CCTV LAYOUT			
SCALE:		1 : 750	A1
CONSULTANT DRAWING NO.: D0121/E3-315			REV. 
CLIENT DRAWING NO.:			REV. 